

Project:

1407 RANDOLPH STREET  
DETROIT, MI 48226

Seal:




Issue Date:  
PERMIT 1/12/2023

Sheet Title:

MAIN FLOOR REFLECTED CEILING PLAN

Sheet Number:

A201

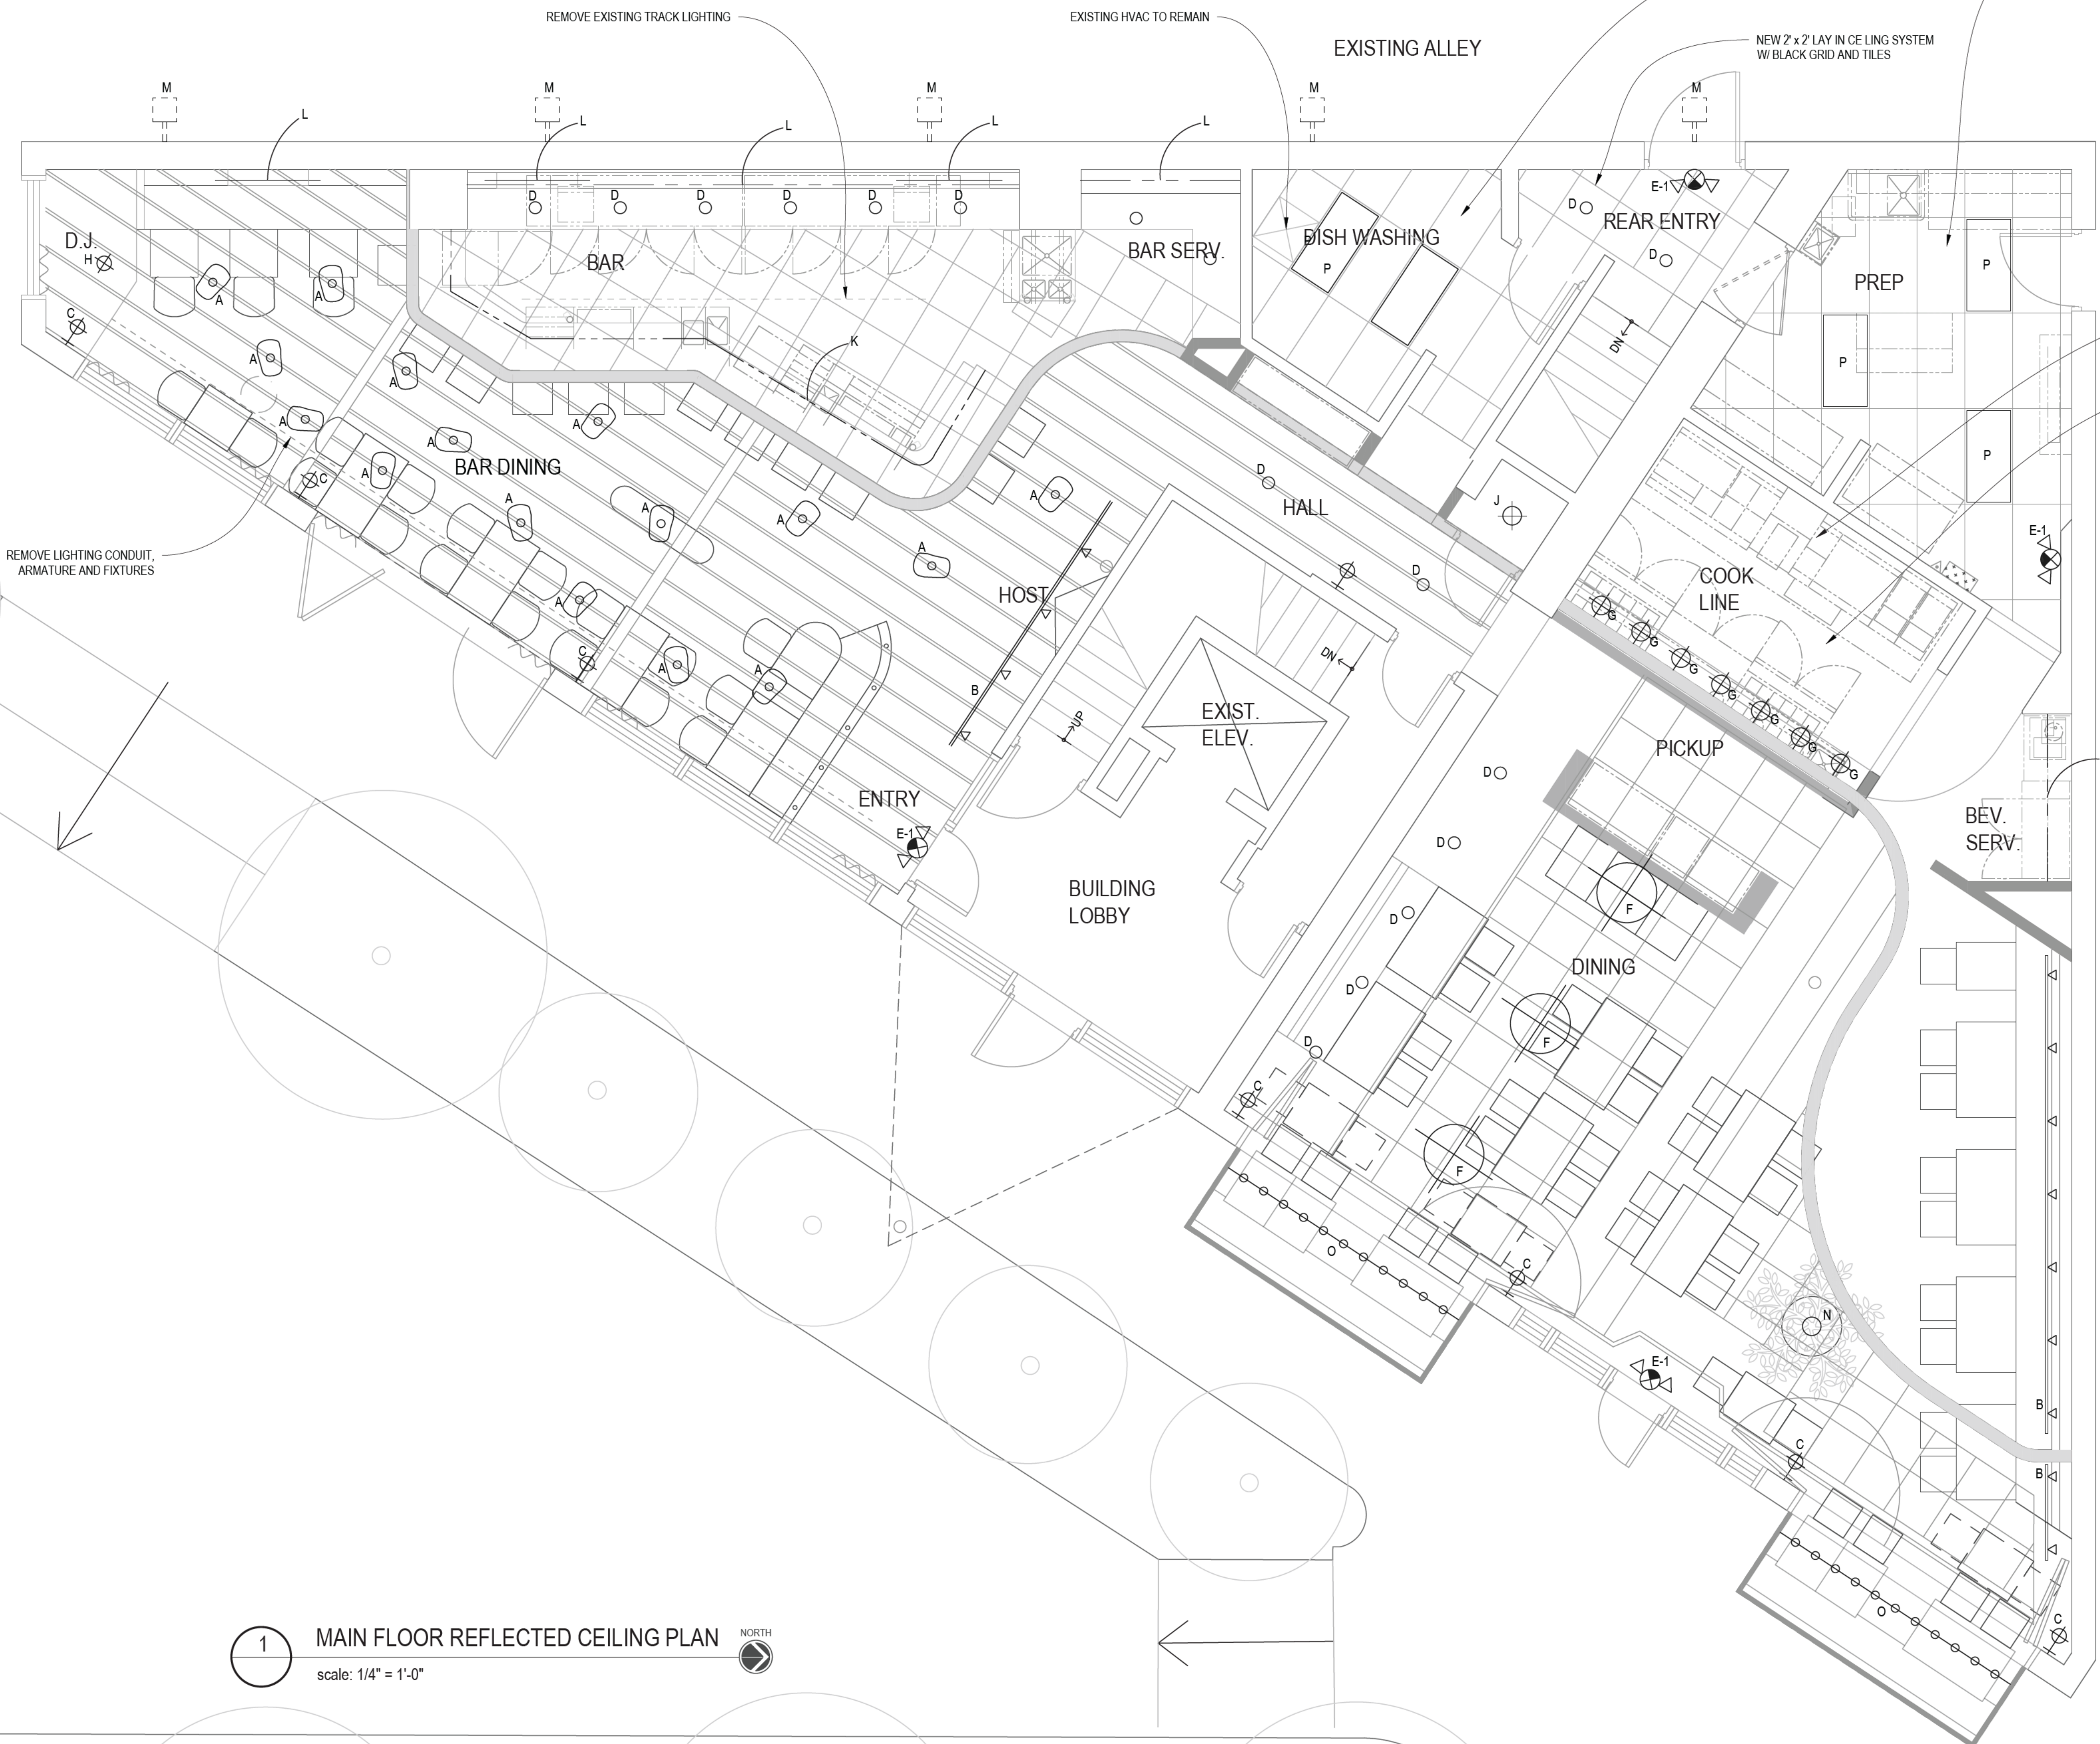

**1** MAIN FLOOR REFLECTED CEILING PLAN  
scale: 1/4" = 1'-0" NORTH

LIGHT FIXTURE SCHEDULE	
MARK	DESCRIPTION
A	DECORATIVE PENDANT BY OWNER - LED - 20W
B	TRACK LITES W/ LED PAR 38 LAMPS - 12W EACH
C	LED WALL SCONCES BY OWNER - 10W
D	JUNO 2" I.C. 600 LUMEN ROUND DOWNLIGHT CONE 2 LED TRIM G2 DC 2800K SPOT - BLACK REFLECTOR AND WHITE TRIM RING
E-1	EMERGENCY LIGHT COMBO W/ BATTERY BACKUP - WHITE
E-2	EMERGENCY LIGHT - WHITE
E-3	EXT. EMERGENCY LIGHT
F	WALL MOUNTED CONDUIT W/ JUNCTION BOX OWNER PROVIDED CUSTOM FIXTURES BY STEVEN FRANK STUDIOS?
G	HATCO HEAT LAMPS
H	SURFACE MOUNTED CYLINDER DOWNLIGHT 3000K LED SPOT
I	RECESSED DOWNLIGHT W/ PAR 38 LED 3000K FLOOD LAMP
J	LED UTILITY SURFACE MOUNT 3000K
K	LED 3000K UNDERBAR WORK LIGHT
L	LED STRIP BY MILLWORK CONTRACTOR
M	WALL MOUNT CYLINDER DOWNLIGHT AT 10' A.F.F.
N	SOLTECH 40W LED GROWLIGHT ON TIMER
O	COMMERCIAL GRADE STRING LIGHTS BY OWNER
P	LED FLAT PANEL 2' x 4' LAY-IN 3000K
Q	NOT USED
R	NOT USED
S	BLACK LIGHT WALL WASH BY OWNER
T	NOT USED
U	PICTURE LIGHT BY OWNER LED BW
V	NEON FEATURE BY OWNER
W	LED WALL SCONCE BY OWNER 2800K 10W
X	TABLE LAMPS BY OWNER 60W
Y	LED WALL SCONCE BY OWNER BW
Z	FLOOR LAMPS BY OWNER 60W

NOTE: ALL LIGHTING FIXTURES TO BE DIMMABLE