

THE FOLLOWING DIMENSION EQUALS ONE INCH WHEN PRINTED TO SCALE.


E

D

C

B

A

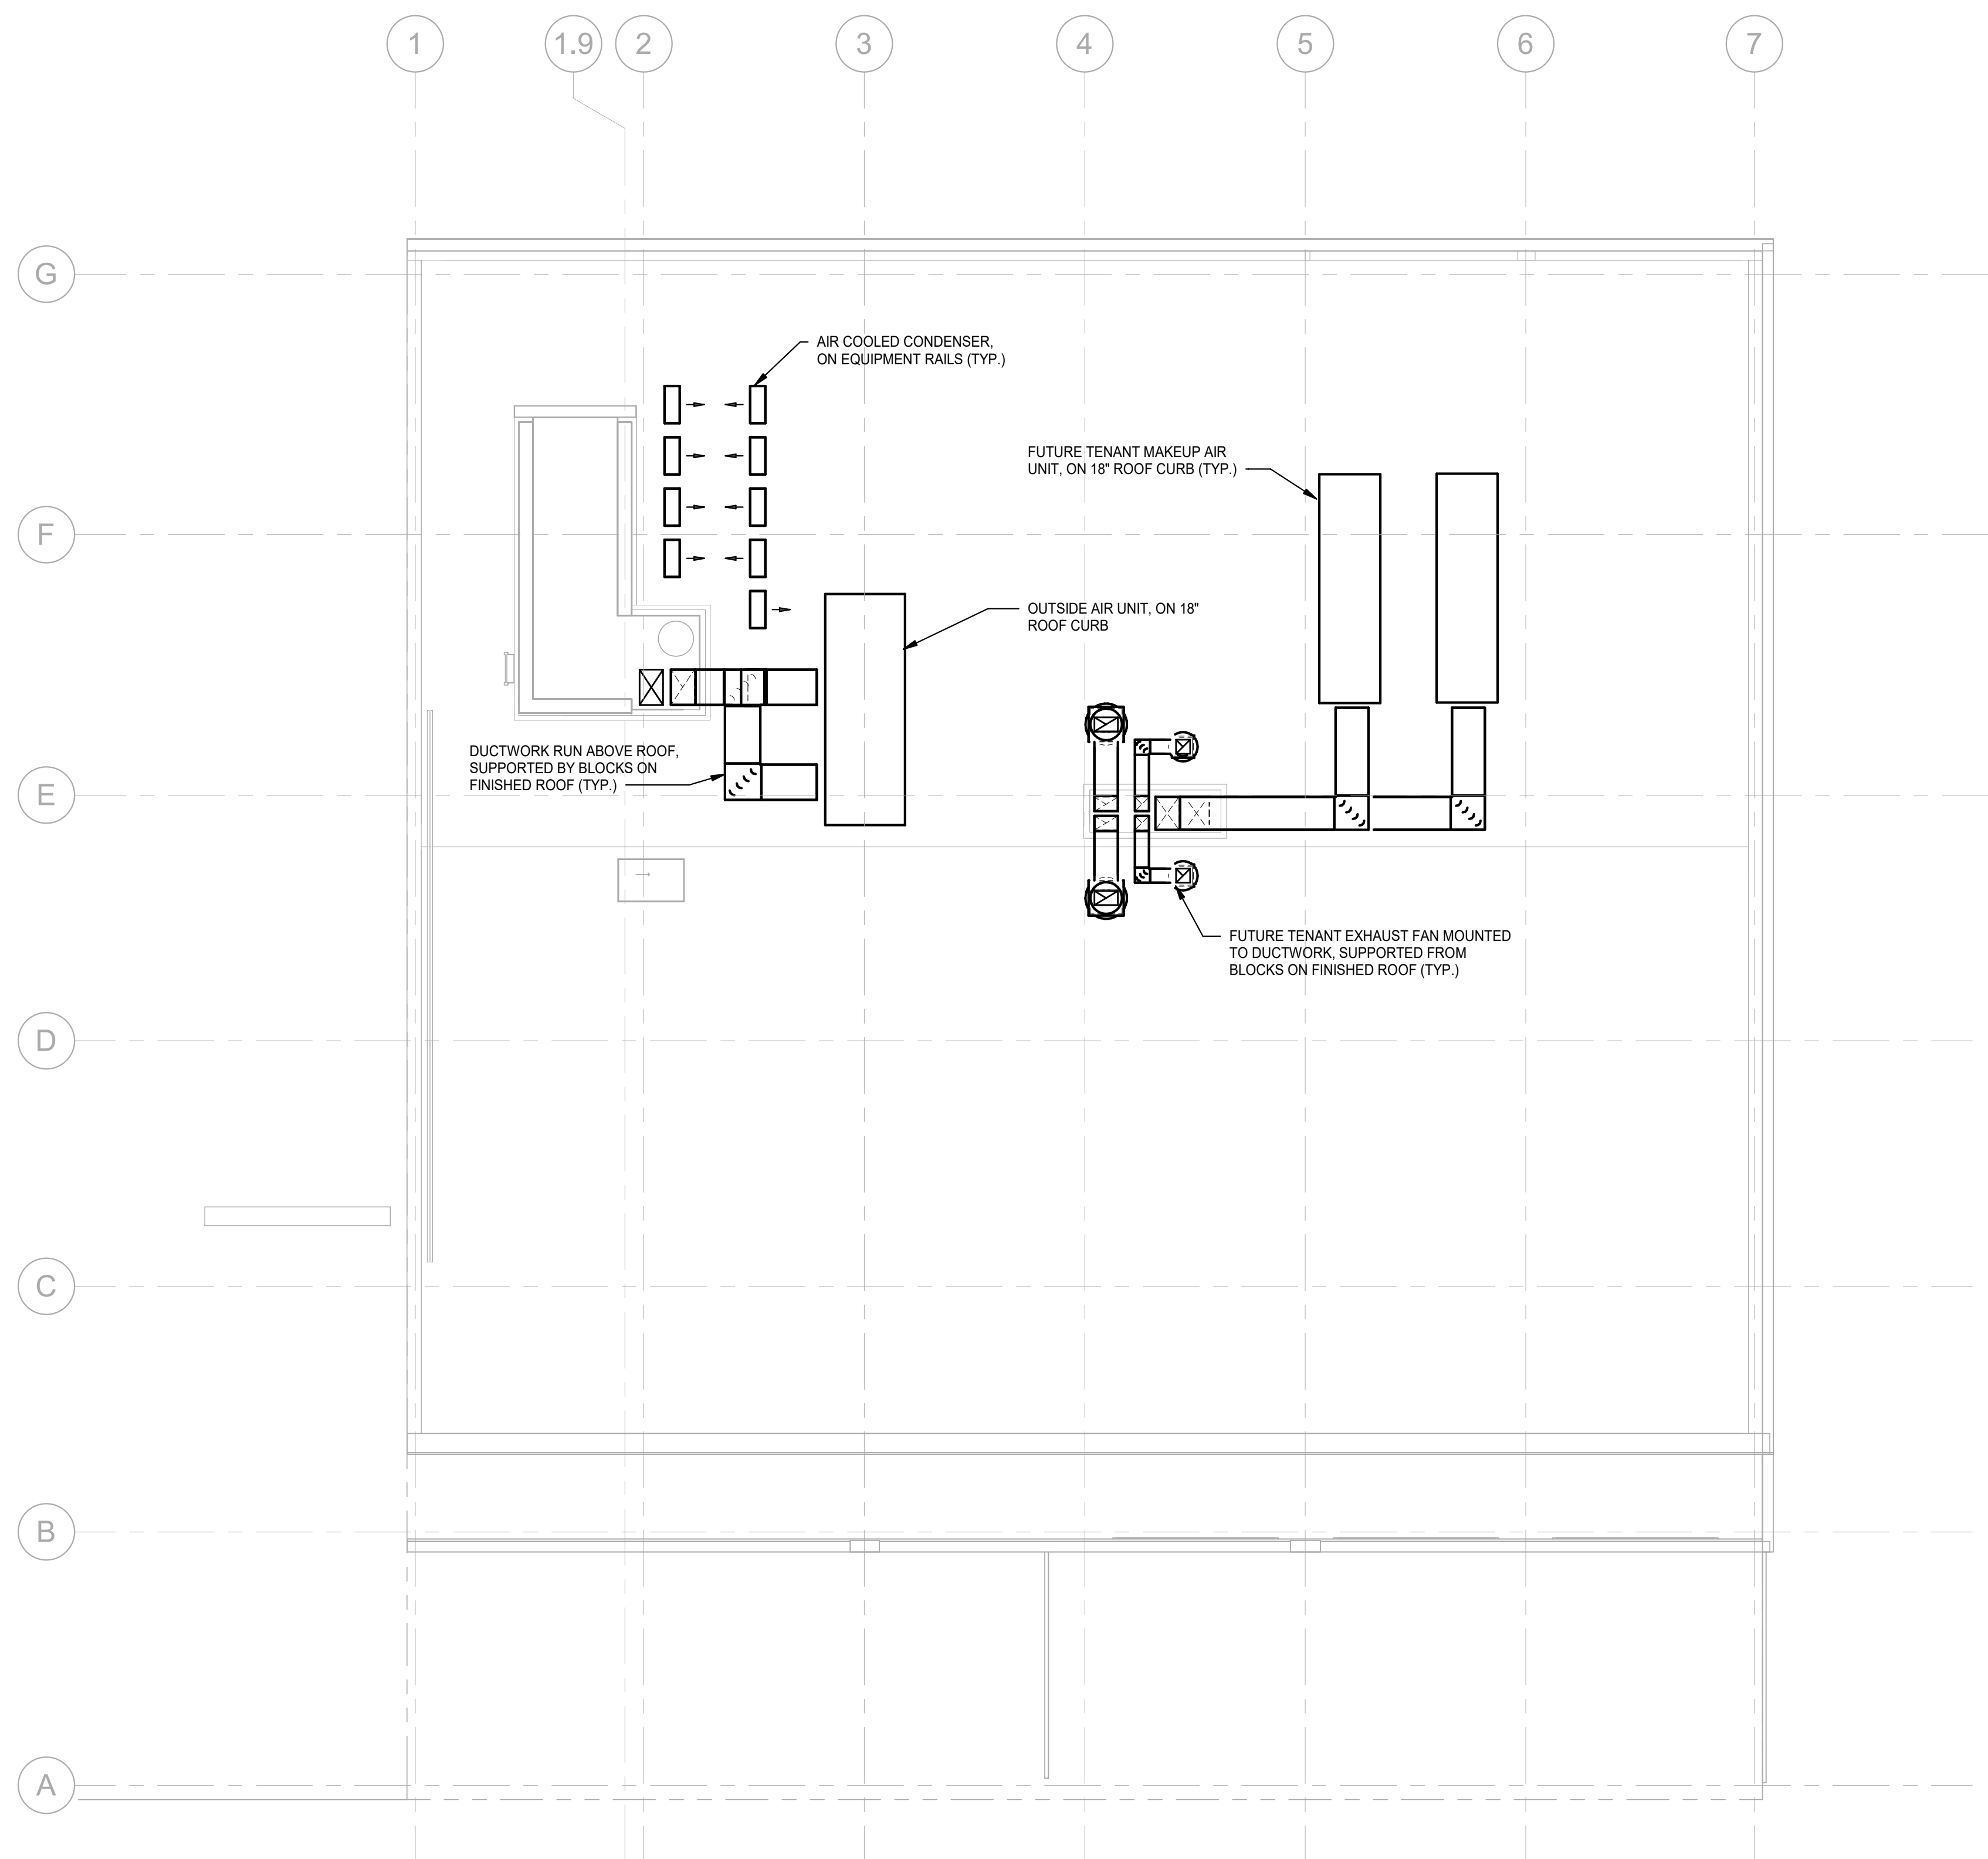

**ROOF HVAC PLAN**  
SCALE: 1/8" = 1'-0"

**SHEET METAL GENERAL NOTES:**

- 1 THESE DRAWINGS ARE DIAGRAMMATIC AND REPRESENT THE GENERAL INTENT AND ARRANGEMENT OF SYSTEMS. THEY ARE NOT TO BE CONSIDERED FABRICATION/COORDINATION/SHOP DRAWINGS. COORDINATION WITH OTHER TRADES IS REQUIRED. PROVIDE THE ADDITIONAL FITTINGS AND OFFSETS THAT WILL BE REQUIRED TO COMPLETE EACH SYSTEM AND TO AVOID INTERFERENCES WITH ALL OTHER SYSTEMS INCLUDING THE STRUCTURE, PIPING SYSTEMS, ELECTRICAL CONDUITS, BUS DUCTS, CABLE TRAY, LIGHT FIXTURES, ETC. AND/OR OTHER SPACE CONSTRAINTS.
- 2 INSTALL SYSTEMS SUCH THAT REQUIRED CLEARANCE AND SERVICE ACCESS SPACE IS PROVIDED AROUND ALL MECHANICAL AND ELECTRICAL EQUIPMENT, AND AROUND ANY COMPONENTS WHICH REQUIRE SERVICE ACCESS.
- 3 PIPING AND DUCTWORK SHALL NOT BE INSTALLED ABOVE ELECTRICAL TRANSFORMERS, SWITCHBOARDS, PANELBOARDS OR MOTOR CONTROL CENTERS.
- 4 COORDINATE AND PROVIDE ACCESS DOORS WITHIN INACCESSIBLE CEILING, SHAFT, AND CHASE AREAS FOR ALL COMPONENTS WHICH REQUIRE SERVICE ACCESS. REFER TO ARCHITECTURAL DRAWINGS FOR CEILING TYPES.
- 5 PROVIDE SUPPLEMENTARY STEEL AS REQUIRED FOR THE PROPER SUPPORT OF ALL SYSTEMS.
- 6 REFER TO ARCHITECTURAL REFLECTED CEILING PLANS FOR DIMENSIONED LOCATION OF GRILLES, REGISTERS, AND DIFFUSERS.
- 7 REFER TO TEMPERATURE CONTROLS STANDARD MOUNTING HEIGHTS DETAIL FOR ELEVATIONS OF WALL MOUNTED TEMPERATURE CONTROL DEVICES.

**# CONSTRUCTION KEY NOTES:**

**KraemerDesignGroup**  
 Detroit, MI | Toledo, OH | Charleston, SC  
 1420 Broadway | Detroit, MI 48226 | p:313.965.5399  
 www.kraemerdsgroup.com

Architect

**Peter Basso Associates Inc**  
 CONSULTING ENGINEERS  
 5145 Livernois, Suite 100  
 Troy, Michigan 48068-3276  
 Tel: 248-879-5666  
 Fax: 248-879-0007  
 www.PeterBassoAssociates.com  
 PBA Project No: 2023-0131

Consultant

**BASCO**  
 DETROIT

Owner

**BROADWAY LOFTS**  
 1326-1336 BROADWAY ST  
 DETROIT, MI

Project

**PRELIMINARY  
 NOT FOR  
 CONSTRUCTION**

Seal

THIS DOCUMENT AND THE IDEAS AND DESIGNS INCORPORATED HEREIN, AS AN INSTRUMENT OF PROFESSIONAL SERVICE ARE THE PROPERTY OF KRAEMER DESIGN GROUP, LLC AND ARE NOT TO BE USED IN WHOLE OR IN PART FOR ANY REASON WITHOUT THE WRITTEN AUTHORIZATION OF KRAEMER DESIGN GROUP, LLC.

©COPYRIGHT 2023 KRAEMER DESIGN GROUP, LLC

Revision \_\_\_\_\_ Date \_\_\_\_\_


Date \_\_\_\_\_ MONTH XX, 2021

Project Number \_\_\_\_\_ Project Number \_\_\_\_\_

Sheet Title  
**ROOF HVAC PLAN**

Sheet Number

**M410**

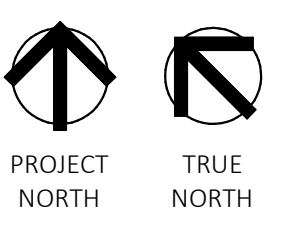

30 X 42 | 01/18/2023 10:53:11 AM | C:\REVIT LOCAL FILES\2023-0131 Broadway Lofts MEP\_v03\_r1\mep\FBA.rvt