


Project:

1427 RANDOLPH STREET
DETROIT, MI 48226

Seal:

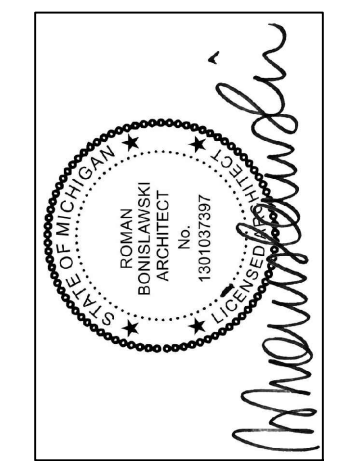

Issue Date:


PERMIT	2/18/2022
REVISION	1/24/2023

Sheet Title:

MAIN FLOOR
REFLECTED CEILING
PLAN

Sheet Number:

A201

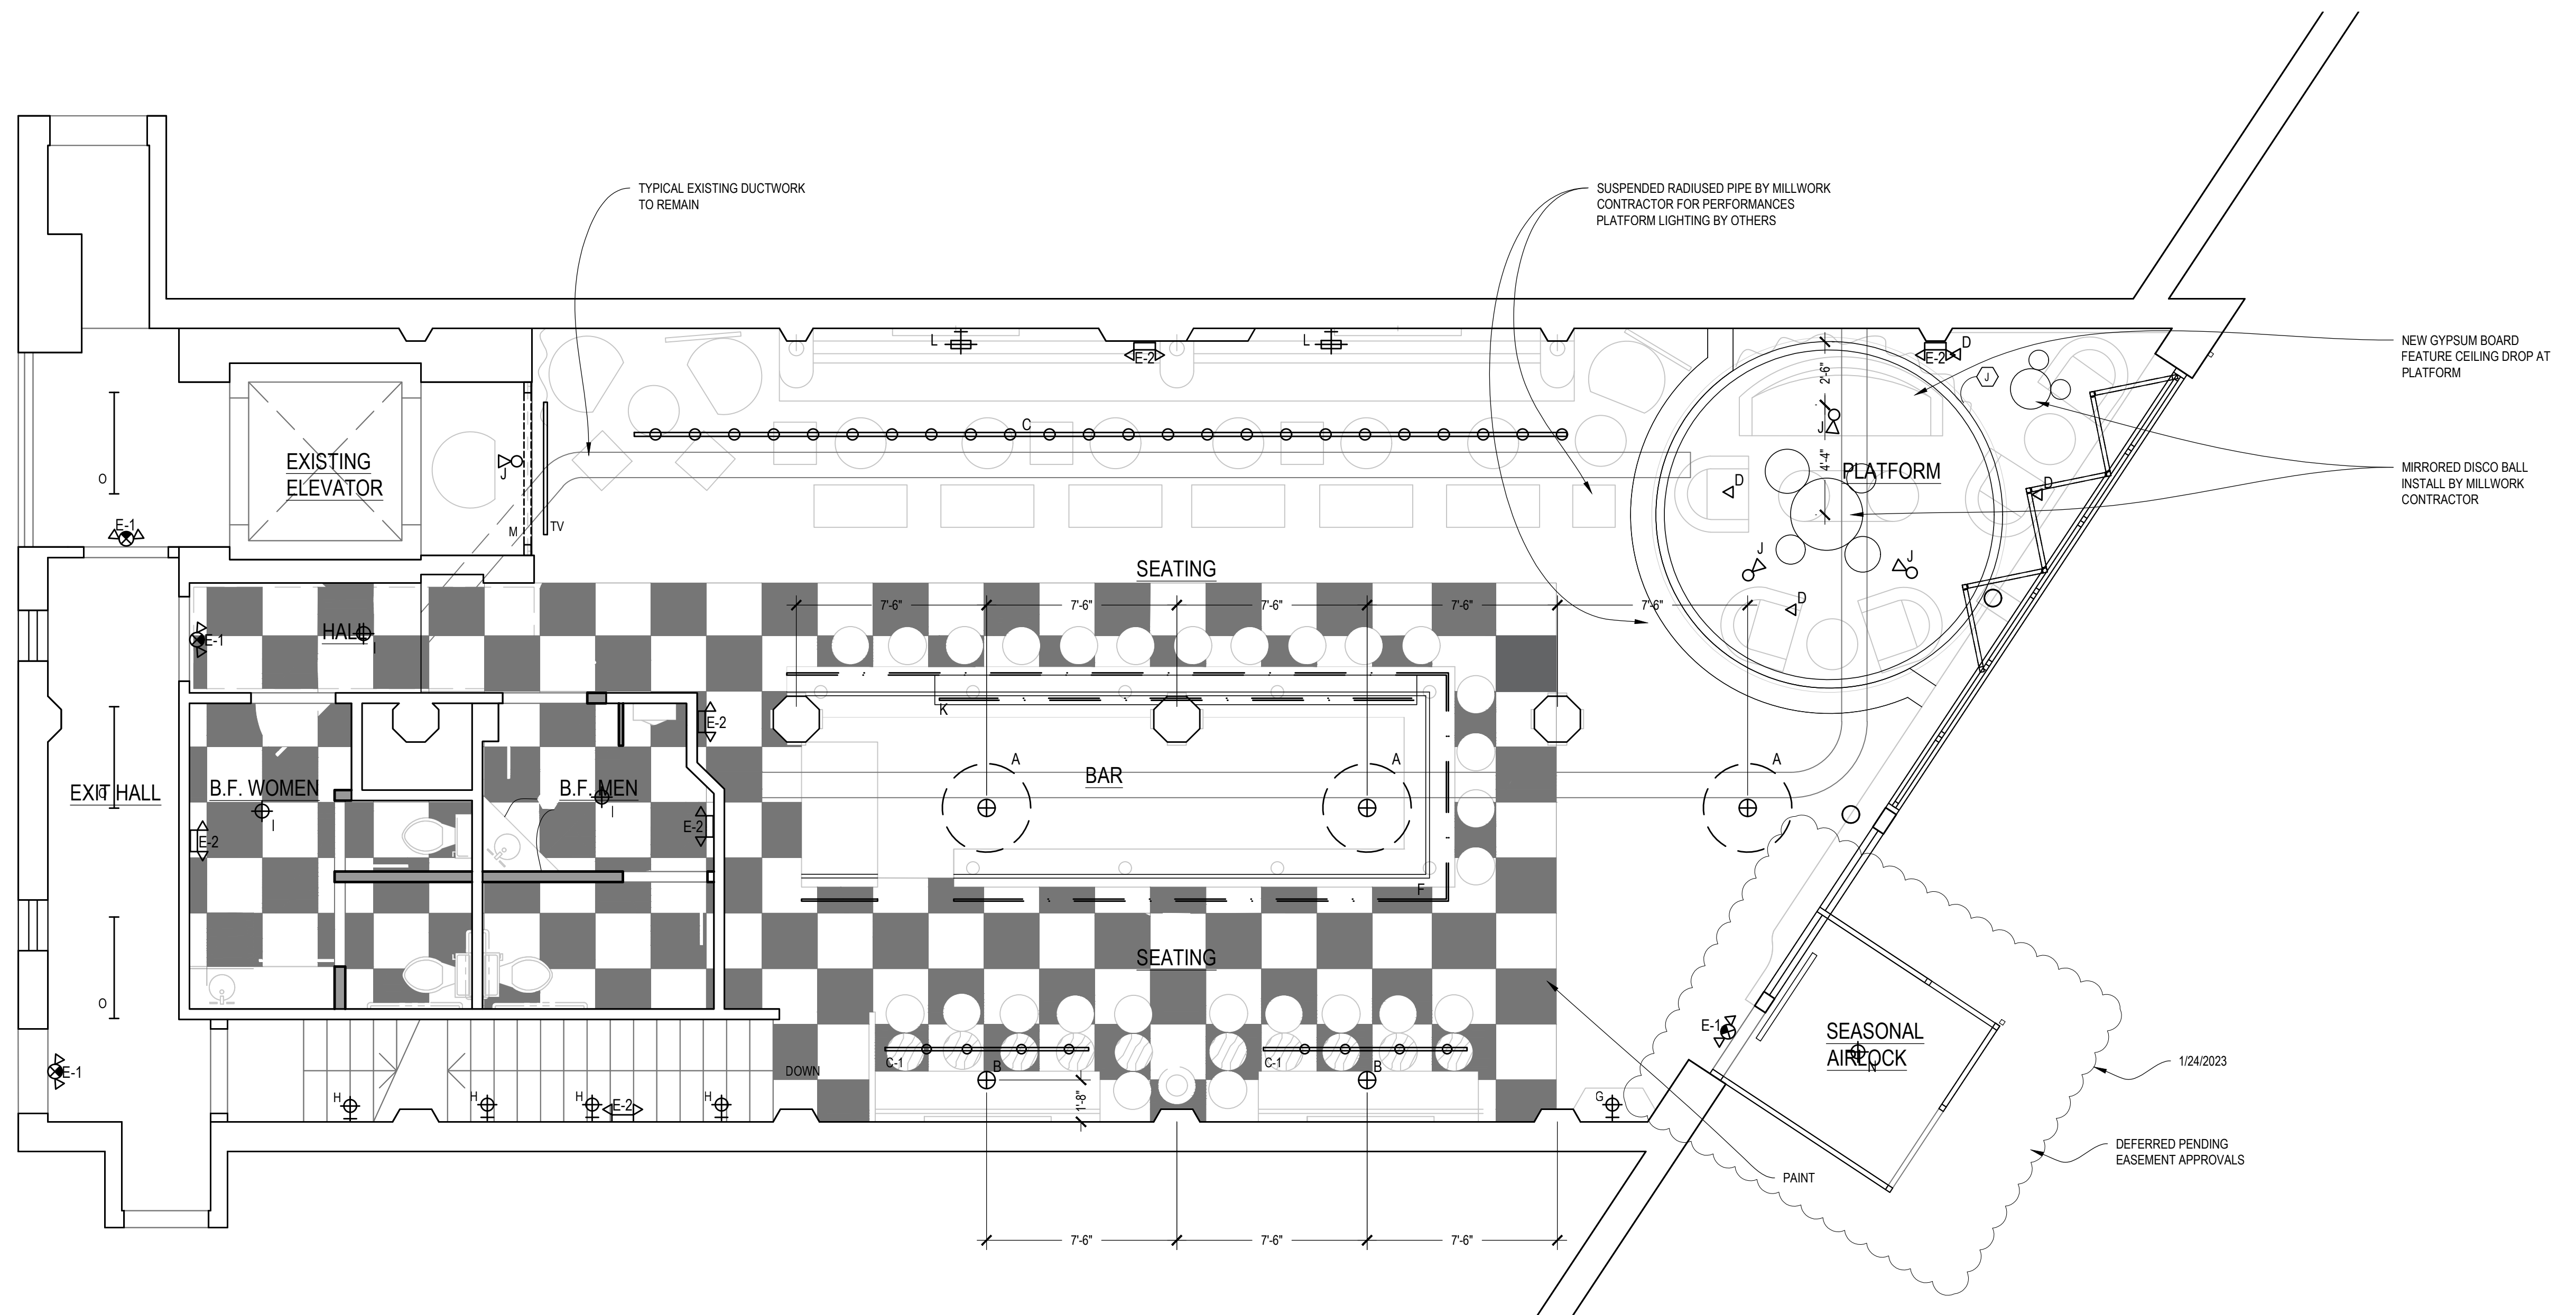

1 MAIN FLOOR REFLECTED CEILING PLAN NORTH
scale: 1/4" = 1'-0"

LIGHT FIXTURE SCHEDULE	
MARK	DESCRIPTION
	CHANDELIER BY OWNER
A	PENDANT FIXTURE BY OWNER
B	EXISTING TRACK
C	RELOCATED 8' PORTION OF EXISTING TRACK W/ (4) PAR36 NARROW SPOT LIGHTS
C-1	DISCO BALL LIGHT PROJECTORS BY OTHERS
D	EXIT & EMERGENCY LIGHT COMBO W/ BATTERY BACKUP
E-1	EXIT & EMERGENCY LIGHT W/ BATTERY BACKUP
E-2	EXTERIOR EMERGENCY LIGHT W/ BATTERY BACKUP
E-3	LINEAR LED UNDER BAR TOP BAR DIE LIGHTING BY MILLWORK CONTRACTOR
F	SCONCE BY OWNER
G	SCONCE BY OWNER
H	MULTI CORD PENDANT BY OWNER
I	SURFACE MOUNTED PAR 36 SPOT HEAD ON CANOPY
J	LED LIQUOR DISPLAY LIGHTING BY MILLWORK CONT.
K	PICTURE LIGHT BY OWNER
L	INTERNALLY ILLUMINATED 'FRAME' AT OPENING
M	PINK PENDANT BY OWNER
N	4' LED UTILITY LIGHT - 3000K
O	WALL SCONCE BY OWNER
P	WALL SCONCE BY OWNER
Q	2x4 FLAT PANEL LED LAY-IN FIXTURE 3000K
R	WALL SCONCE BY OWNER
S	WALL SCONCE BY OWNER
T	POLE LAMP WITH TWO DIRECTIONAL HEADS BY STEVEN FRANK STUDIOS
U	ILLUMINATED BACK BAR FRAME
V	BACK BAR TABLE LAMPS
W	PICTURE LIGHTS BY OWNER

- GENERAL NOTES:
- ALL LIGHTING @ FRONT OF HOUSE TO BE ON DIMMERS.
 - LIGHTING IN WALK-IN COOLERS & HOODS BY MANUFACTURER
 - ALL LED TO BE COLOR TEMPERATURE 3000K.
 - ALL FIXTURES SUPPLIED BY CONTRACTOR TO BE SUBMITTED TO DESIGNER FOR REVIEW PRIOR TO PURCHASE.

1/24/2023

DEFERRED PENDING EASEMENT APPROVALS

PAINT