

LOCATION MAP

© GOOGLE MAPS

# AFFORDABLE HOUSING INNOVO SELDEN ST

439 SELDEN ST, DETROIT, MI, 48201


Copyright © 2025 HDJ Inc. All Rights Reserved



Hooker DeJong Inc.  
ARCHITECTS • ENGINEERS • PLANNERS  
316 Morris Avenue  
Suite 410  
Muskegon, MI 49440  
P 231.722.3407  
F 231.722.2589

SHEET INDEX				
SHEET #	SHEET NAME	DESIGN REVIEW	CURRENT ISSUANCE DATE	CURRENT ISSUANCE DESCRIPTION
COVERSHEET				
CS0.1	COVERSHEET	X	2025.02.10	DESIGN DEVELOPMENT
CS0.2	UNIT MATRIX	X	2025.02.10	DESIGN DEVELOPMENT
ARCHITECTURAL				
AC0.0	CODE REVIEW	X	2025.02.10	DESIGN DEVELOPMENT
AC0.1	SYMBOLS AND ABBREVIATIONS	X	2025.02.10	DESIGN DEVELOPMENT
AC0.2	1ST FLOOR CODE COMPLIANCE PLAN	X	2025.02.10	DESIGN DEVELOPMENT
AC0.3	2ND FLOOR CODE COMPLIANCE PLAN	X	2025.02.10	DESIGN DEVELOPMENT
AC0.4	3RD FLOOR CODE COMPLIANCE PLAN	X	2025.02.10	DESIGN DEVELOPMENT
AC0.5	4TH FLOOR CODE COMPLIANCE PLAN	X	2025.02.10	DESIGN DEVELOPMENT
AC0.6	5TH FLOOR CODE COMPLIANCE PLAN	X	2025.02.10	DESIGN DEVELOPMENT
AC0.7	ROOF CODE COMPLIANCE PLAN	X	2025.02.10	DESIGN DEVELOPMENT
AC0.8	ACCESSIBILITY REQUIREMENTS - ANSI 2009 COMMON AREA	X	2025.02.10	DESIGN DEVELOPMENT
AC0.9	ACCESSIBILITY REQUIREMENTS - ANSI 2009 TYPE A	X	2025.02.10	DESIGN DEVELOPMENT
AC0.10	ACCESSIBILITY REQUIREMENTS - ANSI 2009 TYPE B	X	2025.02.10	DESIGN DEVELOPMENT
AC0.11	ACCESSIBILITY REQUIREMENTS - UFAS	X	2025.02.10	DESIGN DEVELOPMENT
AS1.0	ARCHITECTURAL SITE PLAN	X	2025.02.10	DESIGN DEVELOPMENT
AS1.1	SITE DETAILS	X	2025.02.10	DESIGN DEVELOPMENT
AD0.1	DEMOLITION SITE PLAN	X	2025.02.10	DESIGN DEVELOPMENT
A1.1	OVERALL BASEMENT PLAN	X	2025.02.10	DESIGN DEVELOPMENT
A1.2	OVERALL 1ST FLOOR PLAN	X	2025.02.10	DESIGN DEVELOPMENT
A1.3	OVERALL 2ND FLOOR PLAN	X	2025.02.10	DESIGN DEVELOPMENT
A1.4	OVERALL 3RD FLOOR PLAN	X	2025.02.10	DESIGN DEVELOPMENT
A1.5	OVERALL 4TH FLOOR PLAN	X	2025.02.10	DESIGN DEVELOPMENT
A1.6	OVERALL 5TH FLOOR PLAN	X	2025.02.10	DESIGN DEVELOPMENT
A1.7	OVERALL ROOF PLAN	X	2025.02.10	DESIGN DEVELOPMENT
A2.1	ENLARGED EXISTING UNIT PLAN 0BR-1	X	2025.02.10	DESIGN DEVELOPMENT
A2.2	ENLARGED EXISTING UNIT PLAN 0BR-2	X	2025.02.10	DESIGN DEVELOPMENT
A2.3	ENLARGED EXISTING UNIT PLAN 0BR-3	X	2025.02.10	DESIGN DEVELOPMENT
A2.4	ENLARGED EXISTING UNIT PLAN 1BR-1	X	2025.02.10	DESIGN DEVELOPMENT
A2.5	ENLARGED EXISTING UNIT PLAN 1BR-2	X	2025.02.10	DESIGN DEVELOPMENT
A2.6	ENLARGED EXISTING UNIT PLAN 1BR-3	X	2025.02.10	DESIGN DEVELOPMENT
A2.7	ENLARGED EXISTING UNIT PLAN 1BR-4	X	2025.02.10	DESIGN DEVELOPMENT
A2.8	ENLARGED EXISTING UNIT PLAN 1BR-5	X	2025.02.10	DESIGN DEVELOPMENT
A2.9	ENLARGED UNIT PLAN 0BR-4	X	2025.02.10	DESIGN DEVELOPMENT
A2.10	ENLARGED UNIT PLAN 0BR-5 TYPE A / UFAS	X	2025.02.10	DESIGN DEVELOPMENT
A2.11	ENLARGED UNIT PLAN 1BR-6	X	2025.02.10	DESIGN DEVELOPMENT
A2.12	ENLARGED UNIT PLAN 1BR-7	X	2025.02.10	DESIGN DEVELOPMENT
A2.13	ENLARGED UNIT PLAN 1BR-8	X	2025.02.10	DESIGN DEVELOPMENT
A2.14	ENLARGED UNIT PLAN 1BR-9	X	2025.02.10	DESIGN DEVELOPMENT
A2.15	ENLARGED UNIT PLAN 1BR-10 TYPE A / UFAS	X	2025.02.10	DESIGN DEVELOPMENT
A2.16	ENLARGED UNIT PLAN 2BR-1	X	2025.02.10	DESIGN DEVELOPMENT
A2.17	ENLARGED UNIT PLAN 2BR-2	X	2025.02.10	DESIGN DEVELOPMENT
A2.18	ENLARGED UNIT PLAN 2BR-3 TYPE A / UFAS	X	2025.02.10	DESIGN DEVELOPMENT
A2.19	ENLARGED COMMON AREA PLANS	X	2025.02.10	DESIGN DEVELOPMENT
A3.1	DOOR SCHEDULE, TYPES AND DETAILS	X	2025.02.10	DESIGN DEVELOPMENT
A3.4	WALL TYPES	X	2025.02.10	DESIGN DEVELOPMENT
A4.1	EXTERIOR ELEVATIONS - EXISTING	X	2025.02.10	DESIGN DEVELOPMENT
A4.2	EXTERIOR ELEVATIONS - EXISTING	X	2025.02.10	DESIGN DEVELOPMENT
A4.3	EXTERIOR ELEVATIONS - NEW CONSTRUCTION	X	2025.02.10	DESIGN DEVELOPMENT
A4.4	EXTERIOR ELEVATIONS - NEW CONSTRUCTION	X	2025.02.10	DESIGN DEVELOPMENT
A5.1	BUILDING SECTIONS	X	2025.02.10	DESIGN DEVELOPMENT
A5.2	BUILDING SECTIONS	X	2025.02.10	DESIGN DEVELOPMENT
A6.1	WALL SECTIONS AND DETAILS	X	2025.02.10	DESIGN DEVELOPMENT
A7.1	INTERIOR ELEVATIONS	X	2025.02.10	DESIGN DEVELOPMENT
A8.1	BASEMENT REFLECTED CEILING PLAN	X	2025.02.10	DESIGN DEVELOPMENT
A8.2	1ST FLOOR REFLECTED CEILING PLAN	X	2025.02.10	DESIGN DEVELOPMENT
A8.3	2ND FLOOR REFLECTED CEILING PLAN	X	2025.02.10	DESIGN DEVELOPMENT
A8.4	3RD FLOOR REFLECTED CEILING PLAN	X	2025.02.10	DESIGN DEVELOPMENT
A8.5	4TH FLOOR REFLECTED CEILING PLAN	X	2025.02.10	DESIGN DEVELOPMENT
A8.6	5TH FLOOR REFLECTED CEILING PLAN	X	2025.02.10	DESIGN DEVELOPMENT
A9.1	ENLARGED STAIR PLANS AND SECTIONS	X	2025.02.10	DESIGN DEVELOPMENT
A9.2	ENLARGED STAIR PLANS AND SECTIONS	X	2025.02.10	DESIGN DEVELOPMENT
A9.3	ENLARGED ELEVATOR PLANS AND SECTIONS	X	2025.02.10	DESIGN DEVELOPMENT
INTERIORS				
I1.0	BASEMENT FINISH PLAN	X	2025.02.10	DESIGN DEVELOPMENT
I1.1	OVERALL 1ST FLOOR FINISH PLAN	X	2025.02.10	DESIGN DEVELOPMENT
I1.2	OVERALL 2ND FLOOR FINISH PLAN	X	2025.02.10	DESIGN DEVELOPMENT
I1.3	OVERALL 3RD FLOOR FINISH PLAN	X	2025.02.10	DESIGN DEVELOPMENT
I1.4	OVERALL 4TH FLOOR FINISH PLAN	X	2025.02.10	DESIGN DEVELOPMENT
I1.5	OVERALL 5TH FLOOR FINISH PLAN	X	2025.02.10	DESIGN DEVELOPMENT
I2.0	INTERIOR FINISH SELECTIONS	X	2025.02.10	DESIGN DEVELOPMENT
I2.1	EXISTING BUILDING UNIT FINISH SCHEDULE	X	2025.02.10	DESIGN DEVELOPMENT
I2.2	NEW BUILDING UNIT FINISH SCHEDULE	X	2025.02.10	DESIGN DEVELOPMENT
I2.3	EXISTING BUILDING COMMON AREA FINISH SCHEDULE	X	2025.02.10	DESIGN DEVELOPMENT
I2.4	NEW BUILDING COMMON AREA FINISH SCHEDULE	X	2025.02.10	DESIGN DEVELOPMENT
STRUCTURAL				
S1.10	GROUND FLOOR PLAN	X	2025.02.10	DESIGN DEVELOPMENT
S1.20	2ND FLOOR FRAMING PLAN - BEAMS	X	2025.02.10	DESIGN DEVELOPMENT
S1.21	MILD REINF	X	2025.02.10	DESIGN DEVELOPMENT
S1.22	PT PLAN	X	2025.02.10	DESIGN DEVELOPMENT
S1.23	WALL PLAN	X	2025.02.10	DESIGN DEVELOPMENT
S1.24	SHEARWALL PLAN	X	2025.02.10	DESIGN DEVELOPMENT
S1.30	3RD FLOOR FRAMING PLAN	X	2025.02.10	DESIGN DEVELOPMENT
S1.40	4TH FLOOR FRAMING PLAN	X	2025.02.10	DESIGN DEVELOPMENT
S1.50	5TH FLOOR FRAMING PLAN	X	2025.02.10	DESIGN DEVELOPMENT
S1.60	ROOF FRAMING PLAN	X	2025.02.10	DESIGN DEVELOPMENT
FIRE PROTECTION				
FP1.0	BASEMENT FIRE PROTECTION PLAN	X	2025.02.10	DESIGN DEVELOPMENT
FP1.1	FIRST FLOOR FIRE PROTECTION PLAN	X	2025.02.10	DESIGN DEVELOPMENT
FP1.2	SECOND FLOOR FIRE PROTECTION PLAN	X	2025.02.10	DESIGN DEVELOPMENT
FP1.3	THIRD FLOOR FIRE PROTECTION PLAN	X	2025.02.10	DESIGN DEVELOPMENT
FP1.4	FOURTH FLOOR FIRE PROTECTION PLAN	X	2025.02.10	DESIGN DEVELOPMENT
FP1.5	FIFTH FLOOR FIRE PROTECTION PLAN	X	2025.02.10	DESIGN DEVELOPMENT
FP1.6	ROOF FIRE PROTECTION PLAN	X	2025.02.10	DESIGN DEVELOPMENT

SHEET INDEX				
SHEET #	SHEET NAME	DESIGN REVIEW	CURRENT ISSUANCE DATE	CURRENT ISSUANCE DESCRIPTION
PLUMBING				
P0.0	BASEMENT PLUMBING DEMOLITION PLAN	X	2025.02.10	DESIGN DEVELOPMENT
P0.1	FIRST FLOOR PLUMBING DEMOLITION PLAN	X	2025.02.10	DESIGN DEVELOPMENT
P0.2	SECOND FLOOR PLUMBING DEMOLITION PLAN	X	2025.02.10	DESIGN DEVELOPMENT
P0.3	THIRD FLOOR PLUMBING DEMOLITION PLAN	X	2025.02.10	DESIGN DEVELOPMENT
P0.4	FOURTH FLOOR PLUMBING DEMOLITION PLAN	X	2025.02.10	DESIGN DEVELOPMENT
P0.5	ROOF PLUMBING DEMOLITION PLAN	X	2025.02.10	DESIGN DEVELOPMENT
P01.0	BASEMENT DOMESTIC PLUMBING PLAN	X	2025.02.10	DESIGN DEVELOPMENT
P01.1	FIRST FLOOR DOMESTIC PLUMBING PLAN	X	2025.02.10	DESIGN DEVELOPMENT
P01.2	SECOND FLOOR DOMESTIC PLUMBING PLAN	X	2025.02.10	DESIGN DEVELOPMENT
P01.3	THIRD FLOOR DOMESTIC PLUMBING PLAN	X	2025.02.10	DESIGN DEVELOPMENT
P01.4	FOURTH FLOOR DOMESTIC PLUMBING PLAN	X	2025.02.10	DESIGN DEVELOPMENT
P01.5	FIFTH FLOOR DOMESTIC PLUMBING PLAN	X	2025.02.10	DESIGN DEVELOPMENT
P01.6	ROOF DOMESTIC PLUMBING PLAN	X	2025.02.10	DESIGN DEVELOPMENT
P02.1	ENLARGED PLUMBING DOMESTIC PLANS	X	2025.02.10	DESIGN DEVELOPMENT
P02.2	ENLARGED PLUMBING DOMESTIC PLANS	X	2025.02.10	DESIGN DEVELOPMENT
P02.3	ENLARGED PLUMBING DOMESTIC PLANS	X	2025.02.10	DESIGN DEVELOPMENT
P02.4	ENLARGED PLUMBING DOMESTIC PLANS	X	2025.02.10	DESIGN DEVELOPMENT
P02.5	ENLARGED PLUMBING DOMESTIC PLANS	X	2025.02.10	DESIGN DEVELOPMENT
P01.0	BASEMENT GAS PIPING PLAN	X	2025.02.10	DESIGN DEVELOPMENT
P01.1	FIRST FLOOR GAS PIPING PLAN	X	2025.02.10	DESIGN DEVELOPMENT
P01.2	SECOND FLOOR GAS PIPING PLAN	X	2025.02.10	DESIGN DEVELOPMENT
P01.3	THIRD FLOOR GAS PIPING PLAN	X	2025.02.10	DESIGN DEVELOPMENT
P01.4	FOURTH FLOOR GAS PIPING PLAN	X	2025.02.10	DESIGN DEVELOPMENT
P01.5	FIFTH FLOOR GAS PIPING PLAN	X	2025.02.10	DESIGN DEVELOPMENT
P01.6	ROOF GAS PIPING PLAN	X	2025.02.10	DESIGN DEVELOPMENT
P01.0	BASEMENT SANITARY/STORM PLAN	X	2025.02.10	DESIGN DEVELOPMENT
P01.1	FIRST FLOOR SANITARY/STORM PLAN	X	2025.02.10	DESIGN DEVELOPMENT
P01.2	SECOND FLOOR SANITARY/STORM PLAN	X	2025.02.10	DESIGN DEVELOPMENT
P01.3	THIRD FLOOR SANITARY/STORM PLAN	X	2025.02.10	DESIGN DEVELOPMENT
P01.4	FOURTH FLOOR SANITARY/STORM PLAN	X	2025.02.10	DESIGN DEVELOPMENT
P01.5	FIFTH FLOOR SANITARY/STORM PLAN	X	2025.02.10	DESIGN DEVELOPMENT
P01.6	ROOF SANITARY/STORM PLAN	X	2025.02.10	DESIGN DEVELOPMENT
P01.1	PLUMBING SCHEDULES	X	2025.02.10	DESIGN DEVELOPMENT
P01.1	PLUMBING DIAGRAMS, SCHEMATICS AND ISOMETRICS	X	2025.02.10	DESIGN DEVELOPMENT
P01.1	PLUMBING DETAILS	X	2025.02.10	DESIGN DEVELOPMENT
MECHANICAL				
M0.0	BASEMENT MECHANICAL DEMOLITION PLAN	X	2025.02.10	DESIGN DEVELOPMENT
M0.1	FIRST FLOOR MECHANICAL DEMOLITION PLAN	X	2025.02.10	DESIGN DEVELOPMENT
M0.2	SECOND FLOOR MECHANICAL DEMOLITION PLAN	X	2025.02.10	DESIGN DEVELOPMENT
M0.3	THIRD FLOOR MECHANICAL DEMOLITION PLAN	X	2025.02.10	DESIGN DEVELOPMENT
M0.4	FOURTH FLOOR MECHANICAL DEMOLITION PLAN	X	2025.02.10	DESIGN DEVELOPMENT
M0.5	FIFTH FLOOR MECHANICAL DEMOLITION PLAN	X	2025.02.10	DESIGN DEVELOPMENT
M0.6	ROOF MECHANICAL DEMOLITION PLAN	X	2025.02.10	DESIGN DEVELOPMENT
M0.1	BASEMENT HVAC PLAN	X	2025.02.10	DESIGN DEVELOPMENT
M1.1	FIRST FLOOR HVAC PLAN	X	2025.02.10	DESIGN DEVELOPMENT
M1.2	SECOND FLOOR HVAC PLAN	X	2025.02.10	DESIGN DEVELOPMENT
M1.3	THIRD FLOOR HVAC PLAN	X	2025.02.10	DESIGN DEVELOPMENT
M1.4	FOURTH FLOOR HVAC PLAN	X	2025.02.10	DESIGN DEVELOPMENT
M1.5	FIFTH FLOOR HVAC PLAN	X	2025.02.10	DESIGN DEVELOPMENT
M1.6	ROOF HVAC PLAN	X	2025.02.10	DESIGN DEVELOPMENT
M2.1	ENLARGED HVAC PLANS	X	2025.02.10	DESIGN DEVELOPMENT
M2.2	ENLARGED HVAC PLANS	X	2025.02.10	DESIGN DEVELOPMENT
M2.3	ENLARGED HVAC PLANS	X	2025.02.10	DESIGN DEVELOPMENT
M2.4	ENLARGED HVAC PLANS	X	2025.02.10	DESIGN DEVELOPMENT
M2.5	ENLARGED HVAC PLANS	X	2025.02.10	DESIGN DEVELOPMENT
M3.1	MECHANICAL SCHEDULES	X	2025.02.10	DESIGN DEVELOPMENT
M4.1	MECHANICAL DIAGRAMS AND SCHEMATICS	X	2025.02.10	DESIGN DEVELOPMENT
M5.1	MECHANICAL DETAILS	X	2025.02.10	DESIGN DEVELOPMENT
M5.2	MECHANICAL DETAILS	X	2025.01.28	DD QC
ELECTRICAL				
EL1.0	OVERALL BASEMENT LIGHTING PLAN	X	2025.02.10	DESIGN DEVELOPMENT
EL1.1	OVERALL 1ST FLOOR LIGHTING PLAN	X	2025.02.10	DESIGN DEVELOPMENT
EL1.2	OVERALL 2ND FLOOR LIGHTING PLAN	X	2025.02.10	DESIGN DEVELOPMENT
EL1.3	OVERALL 3RD FLOOR LIGHTING PLAN	X	2025.02.10	DESIGN DEVELOPMENT
EL1.4	OVERALL 4TH FLOOR LIGHTING PLAN	X	2025.02.10	DESIGN DEVELOPMENT
EL1.5	OVERALL 5TH FLOOR LIGHTING PLAN	X	2025.02.10	DESIGN DEVELOPMENT
EP1.0	OVERALL BASEMENT POWER & SYSTEMS PLAN	X	2025.02.10	DESIGN DEVELOPMENT
EP1.1	OVERALL 1ST FLOOR POWER & SYSTEMS PLAN	X	2025.02.10	DESIGN DEVELOPMENT
EP1.2	OVERALL 2ND FLOOR POWER & SYSTEMS PLAN	X	2025.02.10	DESIGN DEVELOPMENT
EP1.3	OVERALL 3RD FLOOR POWER & SYSTEMS PLAN	X	2025.02.10	DESIGN DEVELOPMENT
EP1.4	OVERALL 4TH FLOOR POWER & SYSTEMS PLAN	X	2025.02.10	DESIGN DEVELOPMENT
EP1.5	OVERALL 5TH FLOOR POWER & SYSTEMS PLAN	X	2025.02.10	DESIGN DEVELOPMENT
EP1.6	OVERALL ROOF POWER & SYSTEMS PLAN	X	2025.02.10	DESIGN DEVELOPMENT
E2.1	ELECTRICAL ENLARGED PLANS	X	2025.02.10	DESIGN DEVELOPMENT
E2.2	ELECTRICAL ENLARGED PLANS	X	2025.02.10	DESIGN DEVELOPMENT
E2.3	ELECTRICAL ENLARGED PLANS	X	2025.02.10	DESIGN DEVELOPMENT
E2.4	ELECTRICAL ENLARGED PLANS	X	2025.02.10	DESIGN DEVELOPMENT
E2.5	ELECTRICAL ENLARGED PLANS	X	2025.02.10	DESIGN DEVELOPMENT
E3.1	ELECTRICAL SCHEDULES AND CALCULATIONS	X	2025.02.10	DESIGN DEVELOPMENT
E3.2	ELECTRICAL SCHEDULES AND CALCULATIONS	X	2025.02.10	DESIGN DEVELOPMENT
E4.1	ELECTRICAL ONE-LINE DIAGRAMS	X	2025.02.10	DESIGN DEVELOPMENT
E5.1	SYMBOLS LEGEND, ABBREVIATIONS, & NOTES	X	2025.02.10	DESIGN DEVELOPMENT

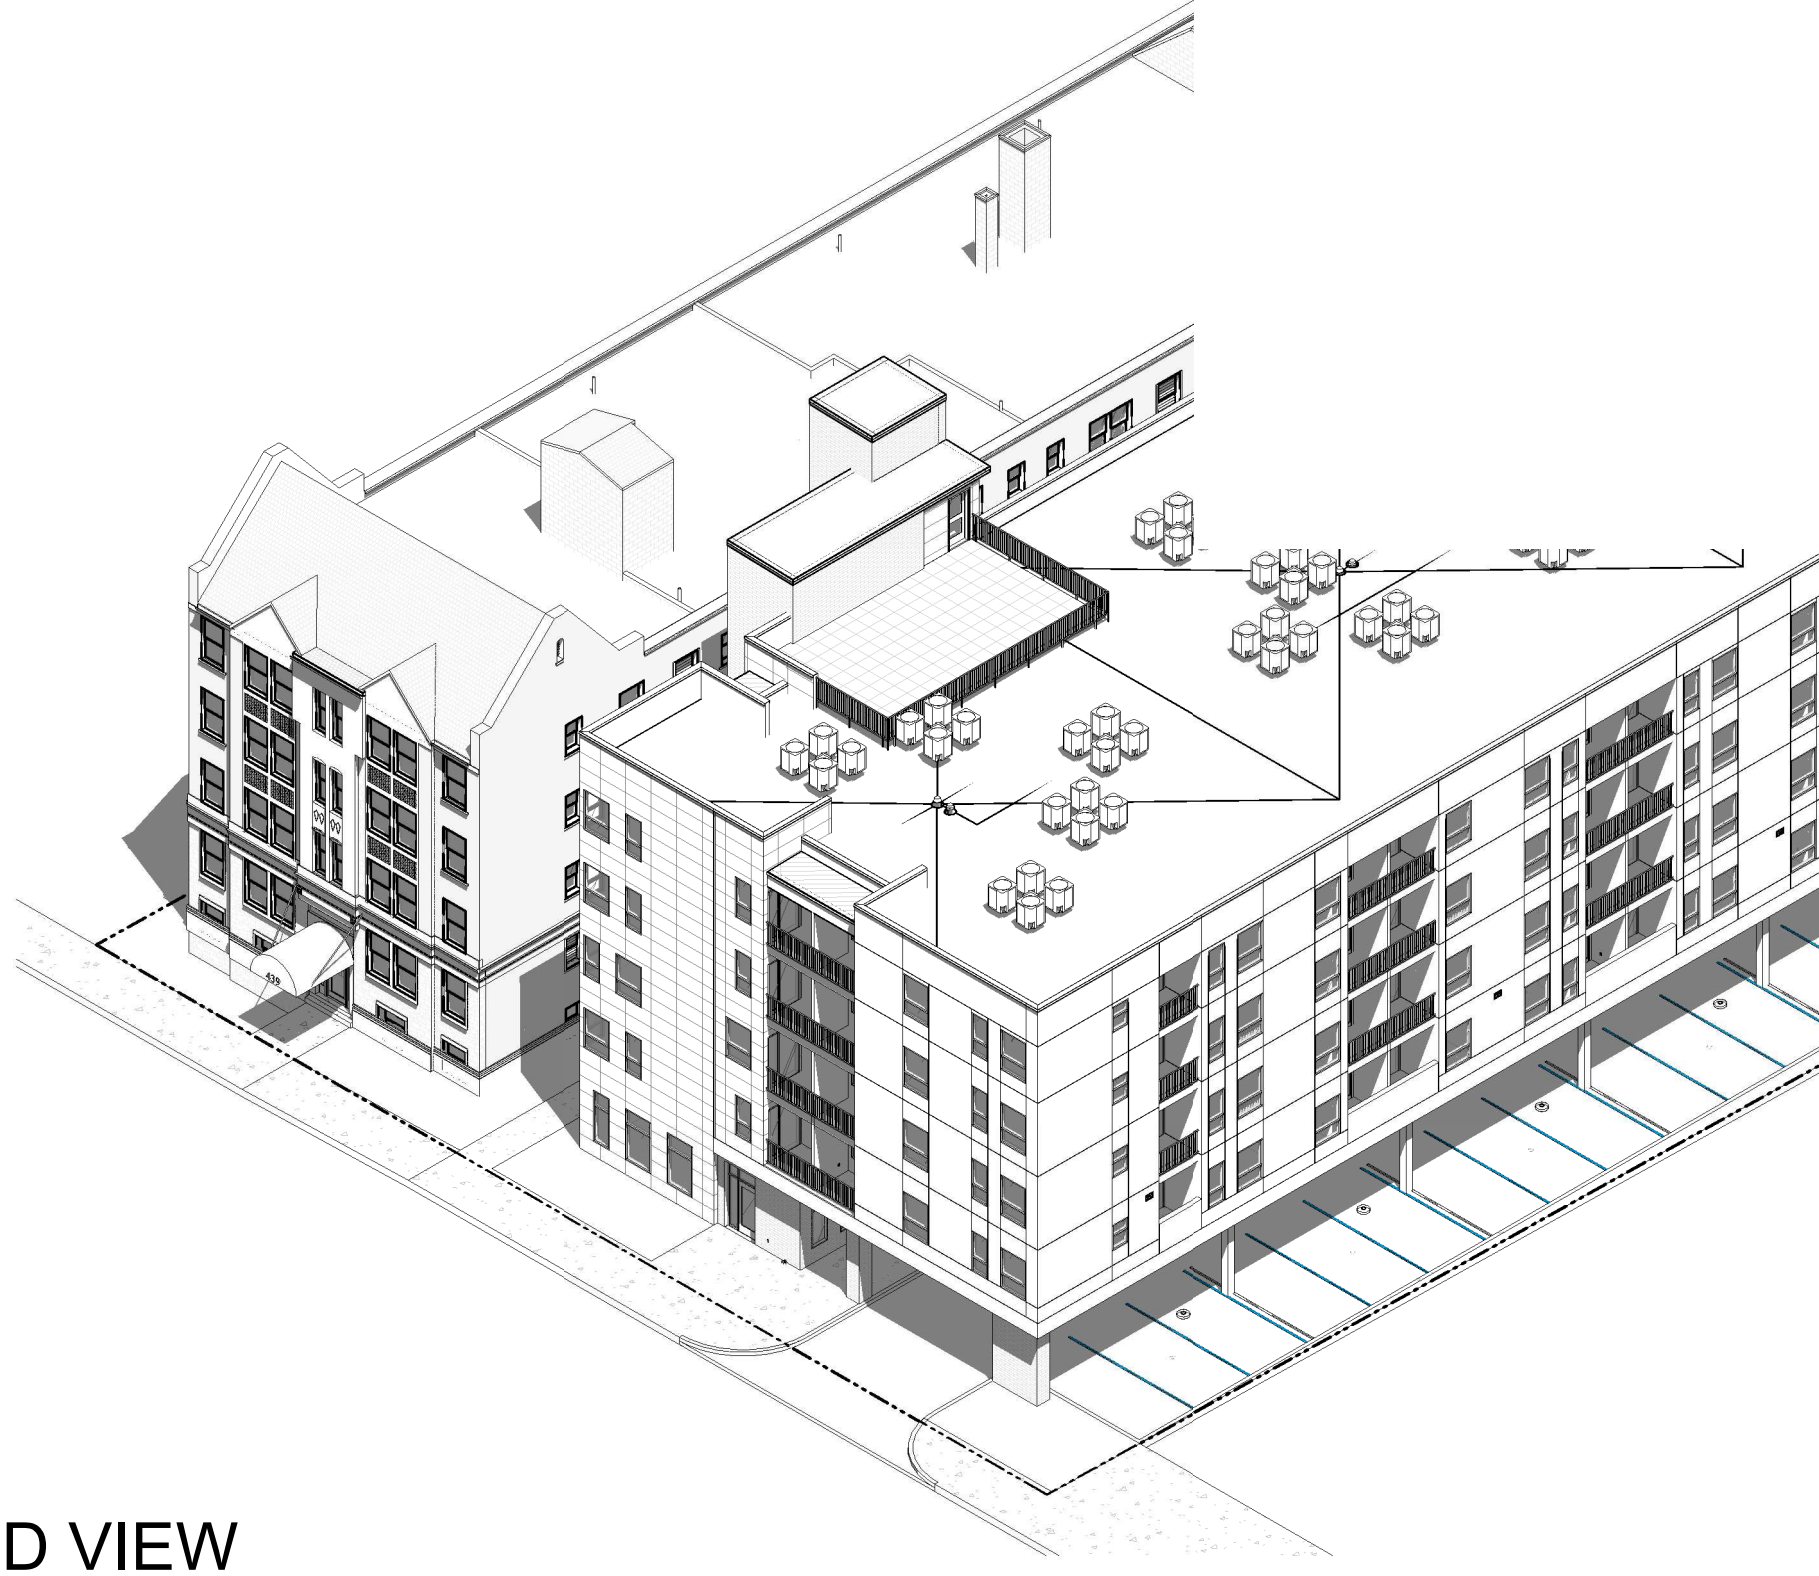

3D VIEW

LEGEND  
UD UNIVERSAL DESIGN  
RIS ROLL-IN SHOWER  
AV ACCESSIBLE COMMUNICATION FEATURES (MAY ALSO BE INDICATED AS HVI)

## LEGAL DESCRIPTION:

PER ALTA COMMITMENT FOR TITLE INSURANCE ISSUED BY: FIRST AMERICAN TITLE INSURANCE COMPANY, COMMITMENT NO.: 962523  
PROPERTY ADDRESS: 439 & 453 SELDEN, DETROIT, MI 48201  
COMMITMENT DATE: FEBRUARY 25, 2022  
(REFERENCE PEA PROJECT NO.: 2022-0521)

LAND IN THE CITY OF DETROIT, WAYNE COUNTY, MI, DESCRIBED AS FOLLOWS:  
LOT(S) 9 AND THE EAST 5 FEET OF LOT 10, ALSO THE WEST 45 FEET OF LOT 10 AND ALL OF LOT 11, BLOCK 91 OF SUBDIVISION OF PART OF CASS FARM ACCORDING TO THE PLAT THEREOF RECORDED IN LIBER 1 OF PLATS, PAGES 175 OF WAYNE COUNTY RECORDS. TOGETHER WITH THAT PORTION OF VACATED SELDEN AVENUE, ADJACENT THERETO AS DISCLOSED IN RESOLUTION RECORDED IN LIBER 52415, PAGE 1024, WAYNE COUNTY RECORDS.

## EXISTING BUILDING

ID 02000804  
439 SELDEN ST.  
INNOVO DETROIT RAINIER

## NEW BUILDING

ID 02000805  
453 SELDEN ST.  
INNOVO DETROIT RAINIER

## PROJECT TEAM

DEVELOPER:  
INNOVO DEVELOPMENT GROUP  
439 SELDEN ST.  
DETROIT, MI 48201  
P. 269-830-9124

ARCHITECT:  
HOOKER DEJONG, INC  
316 MORRIS AVE., SUITE 410  
MUSKEGON, MI 49440  
P. 231-722-3407

STRUCTURAL ENGINEER:  
A. V. SCHWAN & ASSOC. STRUCTURAL ENGINEERS  
6000 EAST THOMAS RD., SUITE 1  
SCOTTSDALE, AZ, 85251  
P. 602-265-4331

MECHANICAL, ELECTRICAL, AND PLUMBING  
ENGINEER, AND FIRE PROTECTION AND FIRE  
ALARM SCOPE DEVELOPER  
HOOKER DEJONG, INC  
316 MORRIS AVE., SUITE 410  
MUSKEGON, MI 49440  
P. 231-722-3407

CIVIL ENGINEER:  
PEA GROUP  
45 W GRAND RIVER AVE., SUITE 501  
DETROIT, MI 48226  
P. 844-813-2949

GENERAL CONTRACTOR:

-

-

-

ARCHITECT (PRINT NAME) DATE:  
BY (SIGNATURE):

SPONSOR / DEVELOPER (PRINT NAME) DATE:  
BY (SIGNATURE AND TITLE):

CONTRACTOR (PRINT NAME) DATE:  
BY (SIGNATURE AND TITLE):

MORTGAGEE / SURETY (PRINT NAME) DATE:  
BY (SIGNATURE AND TITLE):

CONTRACTOR'S BONDING COMPANY (PRINT NAME) DATE:  
BY (SIGNATURE AND TITLE):

INNOVO SELDEN ST

DD QC - 01/28/2025