


- ELECTRICAL KEY:**
- SWITCH W/ DUPLEX OUTLET
 - DUPLEX OUTLET
 - 220V. DUPLEX OUTLET
 - W.P. WATER PROOF OUTLET
 - GROUND FAULT INTERRUPTER
 - SINGLE POLE SWITCH
 - 3-WAY SWITCH
 - CEILING LIGHT FIXTURE
 - RECESSED LIGHT FIXTURE
 - CHANDELIER
 - FLUORESCENT LIGHT
 - COACH LAMP LIGHT
 - CEILING FAN W/ LIGHT
 - DOUBLE SPOTLIGHT
 - VANITY BAR LIGHT
 - 110V. SMOKE DETECTOR INTERCONNECTED WITH BATTERY BACK-UP
 - CEILING EXHAUST FAN 50 C.F.M.
 - CEILING EXHAUST FAN W/ LIGHT
 - CARBON MONOXIDE ALARM WITH BATTERY BACK-UP
 - CABLE TELEVISION OUTLET
 - RECEPTICAL PANEL; 120 / 240V- 1PH-3W
 - EXISTING ELECTRICAL METER

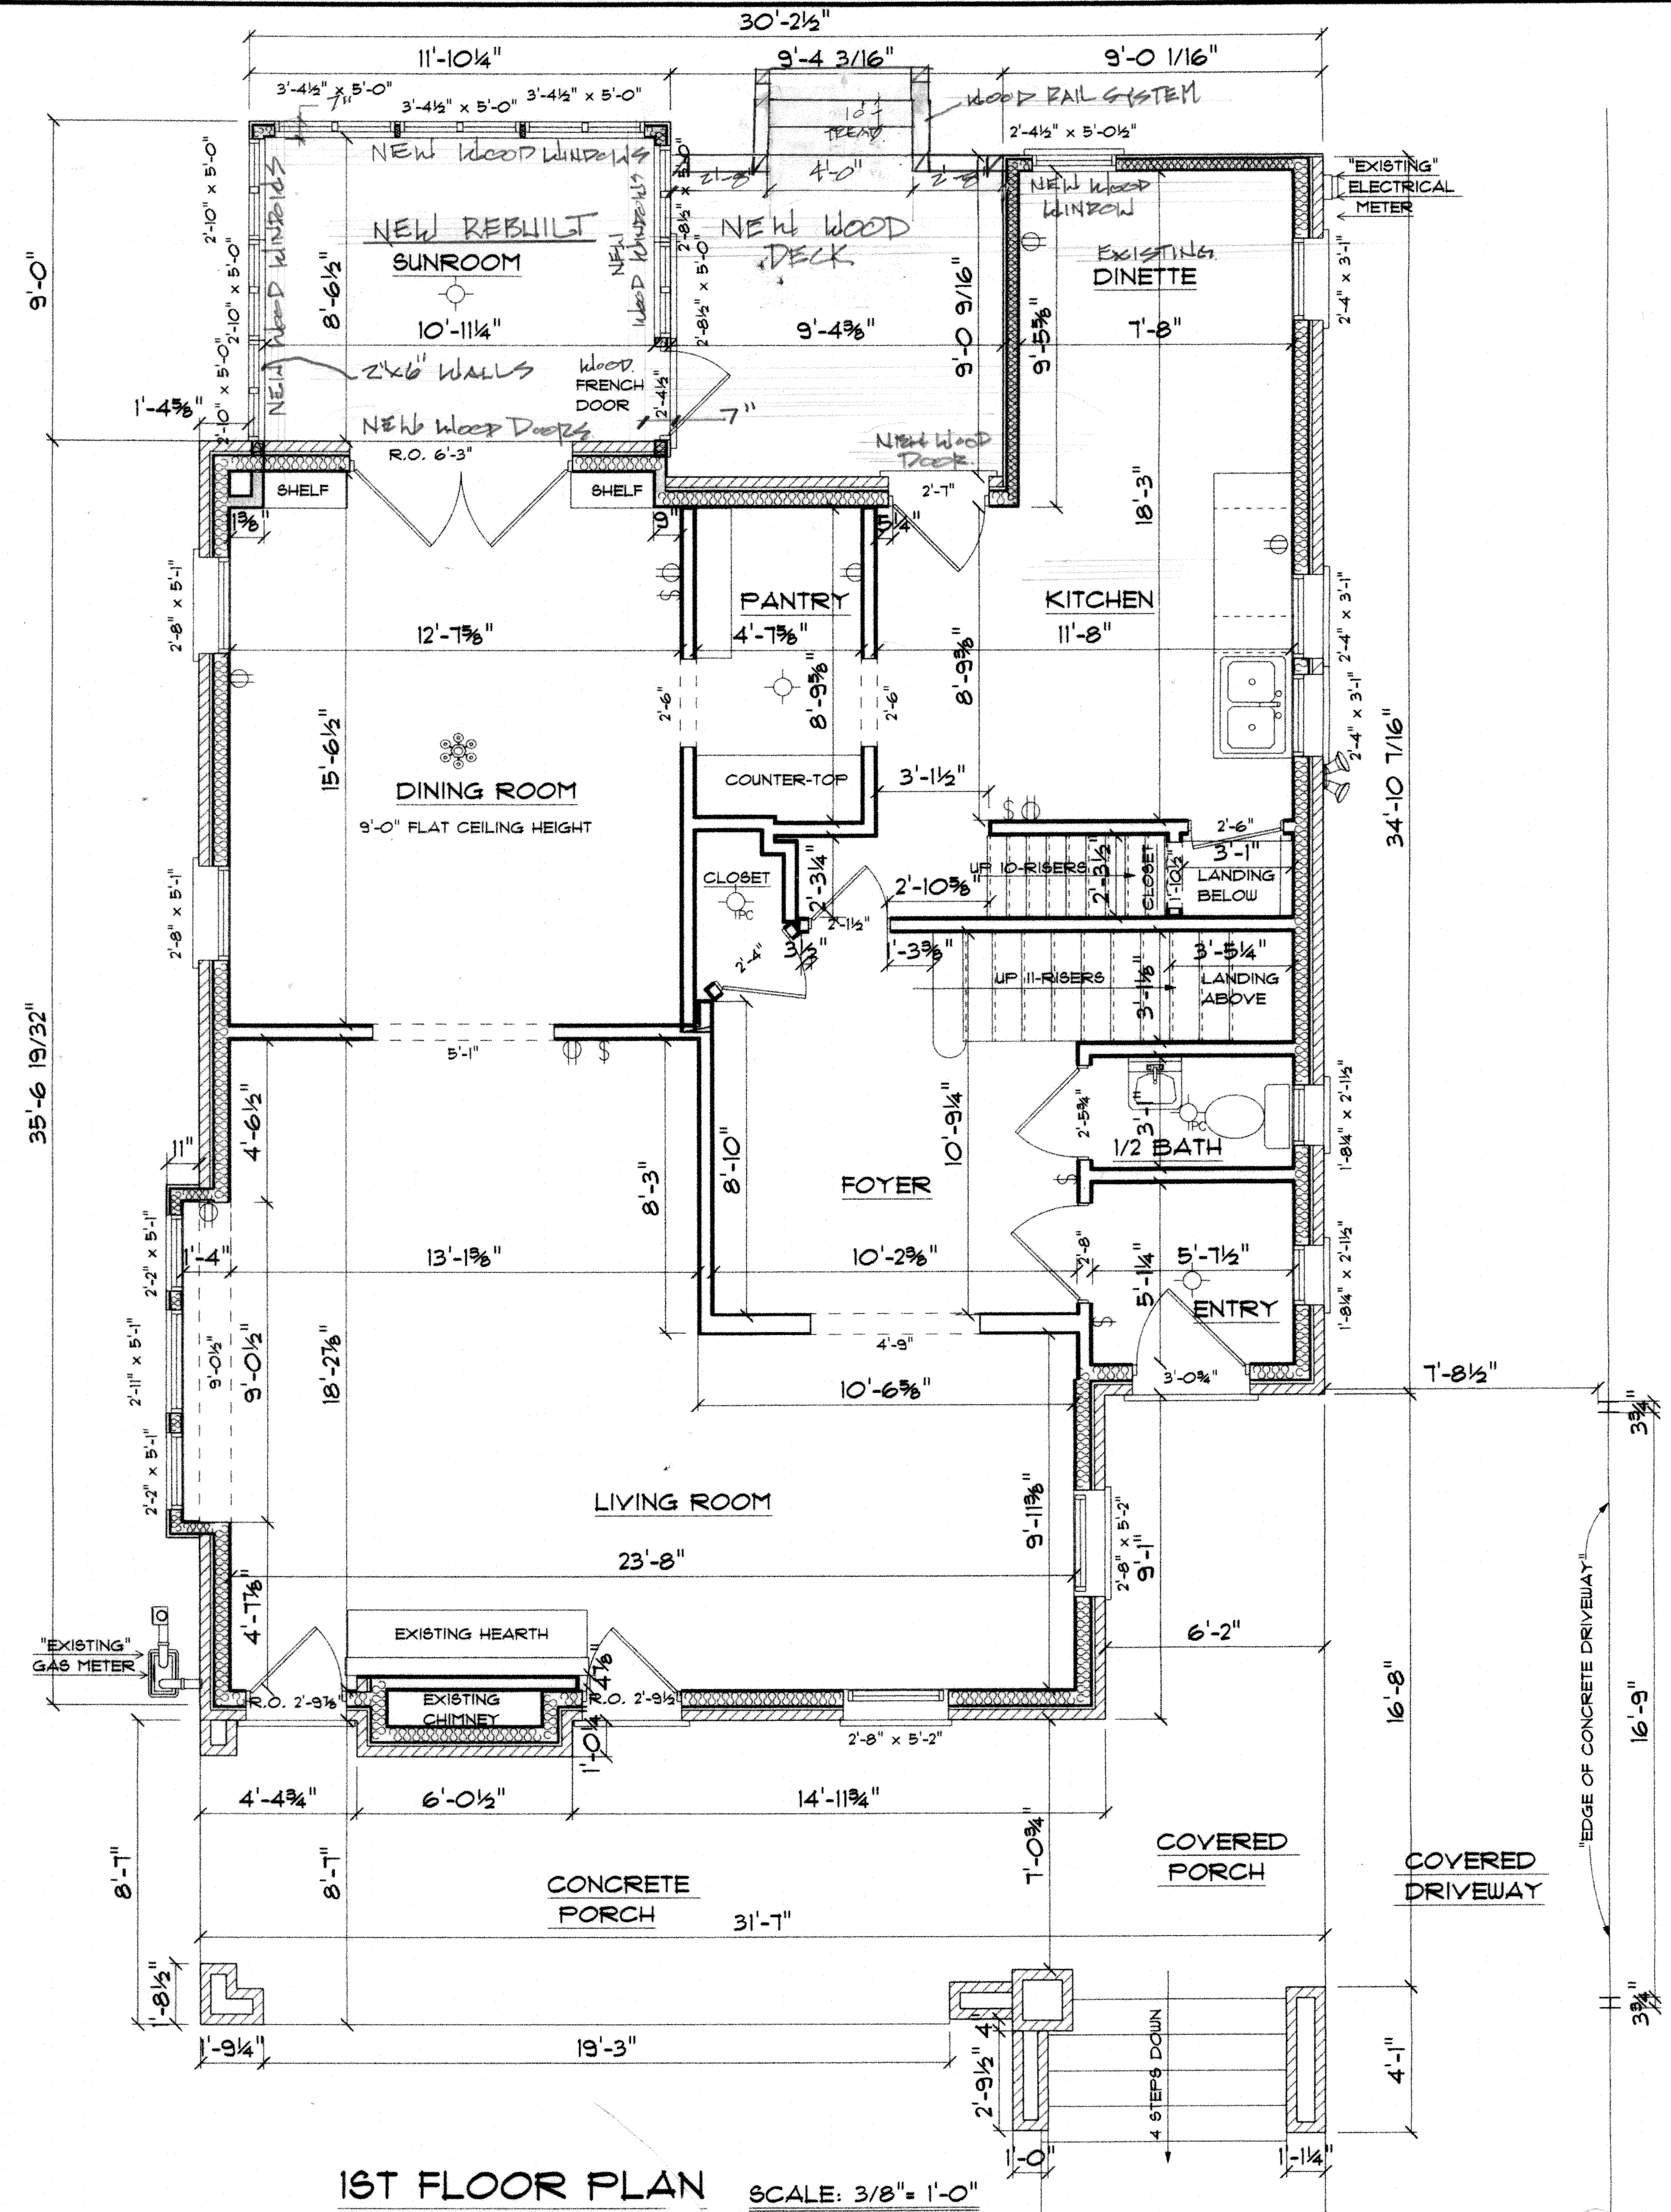

1ST FLOOR PLAN SCALE: 3/8" = 1'-0"

BC Design
 Blueprinting & Design
 Bruce A. Claretto
 734-775-3127

DATE	
DRAWING#	1173
SHEET NO.	A-1