

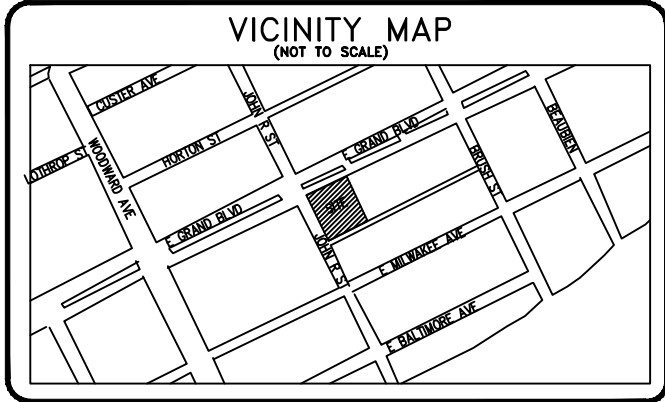
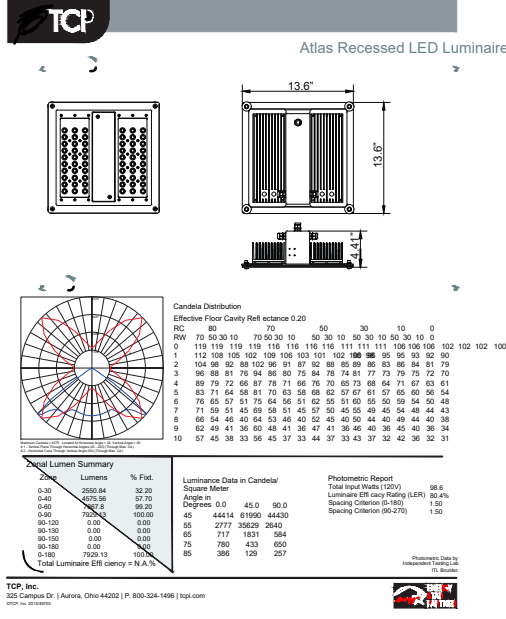
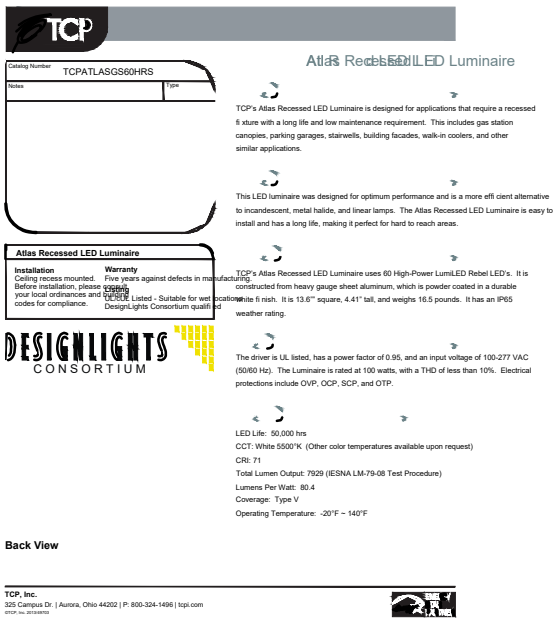


LUMINAIRE SCHEDULE							
Symbol	Label	Qty	Catalog Number	Description	Lamp	File	Lumens LLF Watts
	A	6	DSX1 LED P3 30K VLS	DSX1 LED Visual Comfort, P3 asymmetric Type V distribution 30K	LED	DSX1_LED_P3_30K_VLS.ies	Absolute 0.95 160
	C	10	DSXW1 LED 10C 350 30K ASYDF MVOL T HS	DSXW1 LED WITH (1) 10 LED LIGHT ENGINES, TYPE ASYDF OPTIC, 3000K @ 350mA WITH HOUSE-SIDE SHIELDS.	LED	DSXW1_LED_10C_350_30K_ASYDF_MVOL_T_HS.ies	Absolute 0.81 13.3
	D	24	TCPATLASG560HRS ATLAS RECESSED LED LUMINAIRE	Recessed Led Luminaire white finish input voltage 100-277 vac led life: 50,000 hrs	LED	TCPATLASG560HRS	Absolute 80.4 98.6

NOTE: ALL OUTSIDE LIGHTING WILL BE IN COMPLIANCE WITH THE STANDARDS OF THE ZONING ORDINANCE TO PREVENT ALL OFF-SITE GLARE.

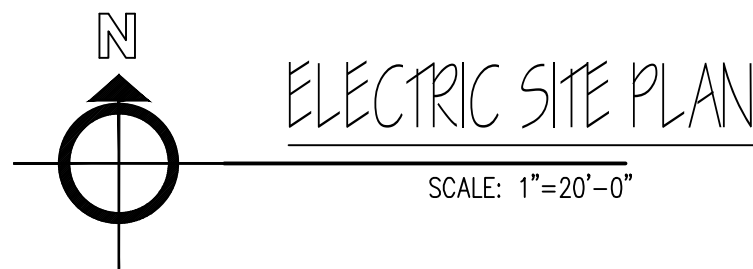

D-Series Size 1
LED Wall Luminaire

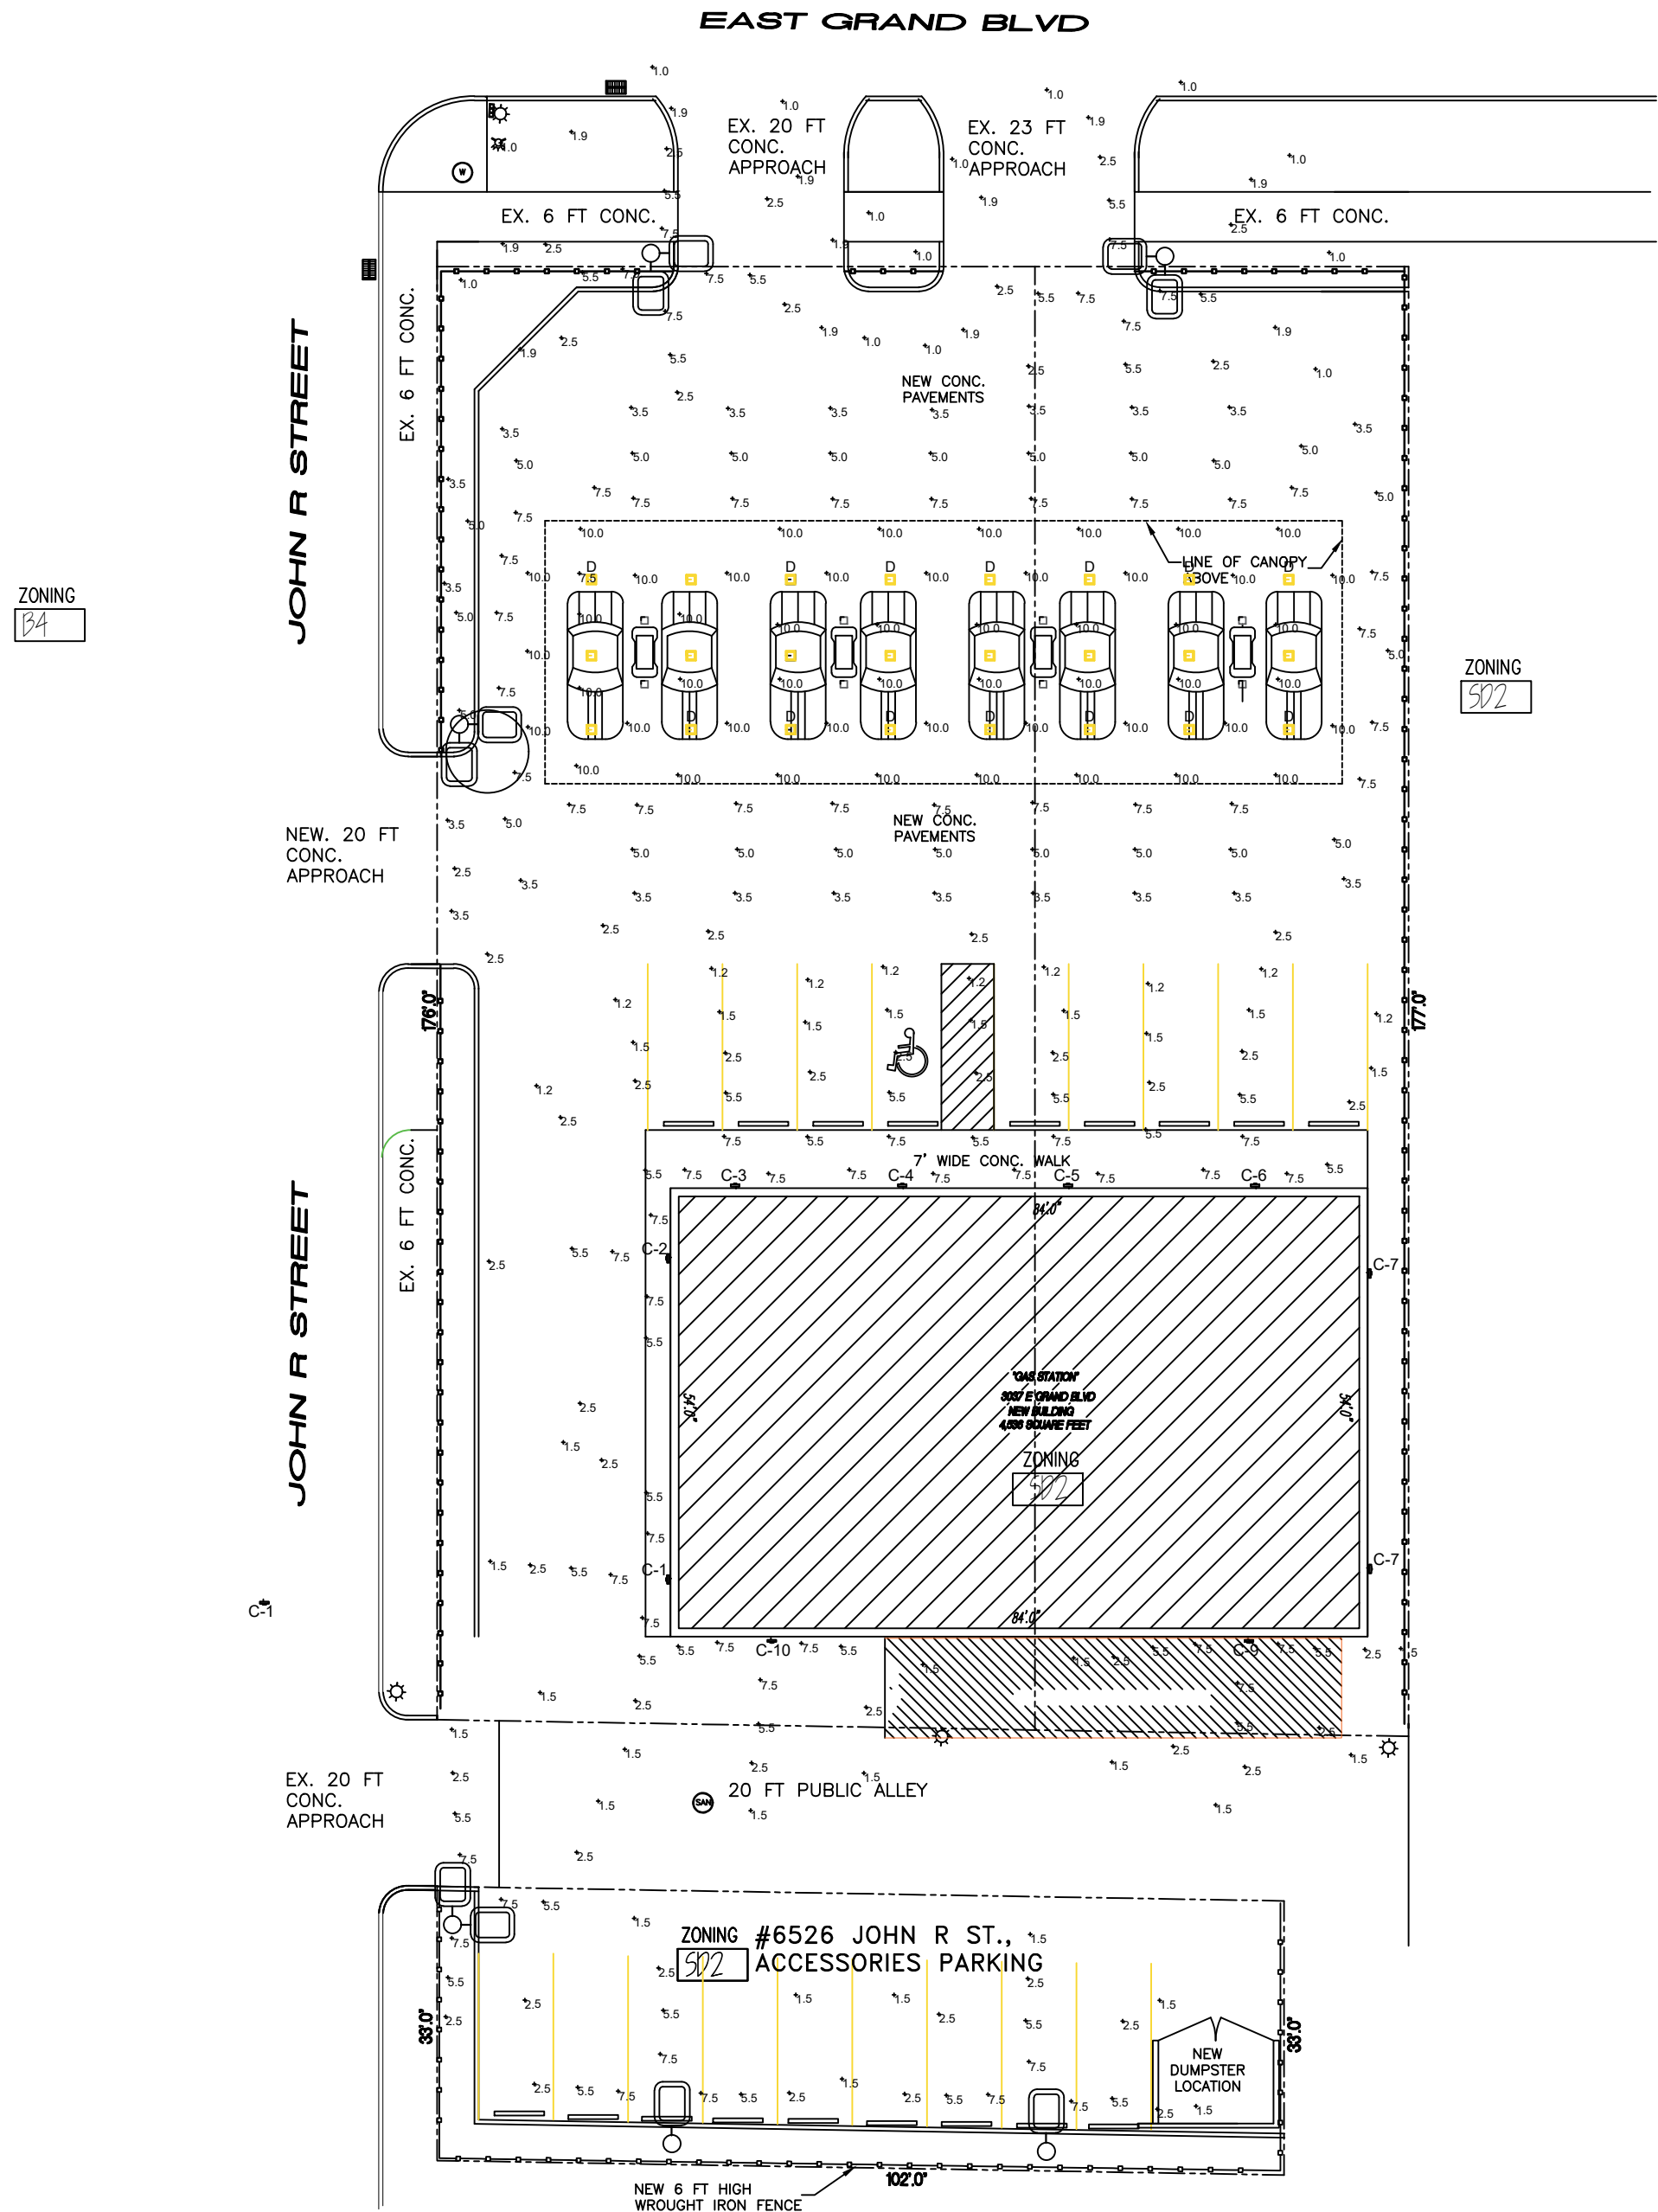

d'series

 
 
Specifications

Luminaire

Width: 13-3/4" (35.1 cm)
Depth: 10" (25.4 cm)
Height: 6-3/8" (16.2 cm)

Back Box (BBW, ELCW)

Width: 13-3/4" (35.1 cm)
Depth: 4" (10.2 cm)
Height: 6-3/8" (16.2 cm)



D-Series Size 1
LED Area Luminaire


 


d'series

Specifications

EPA:

Length: 33" (84 cm)
Width: 13" (33 cm)
Height H1: 7-1/2" (19 cm)
Height H2: 3-1/2" (9 cm)
Weight (max): 27 lbs (12.2 kg)

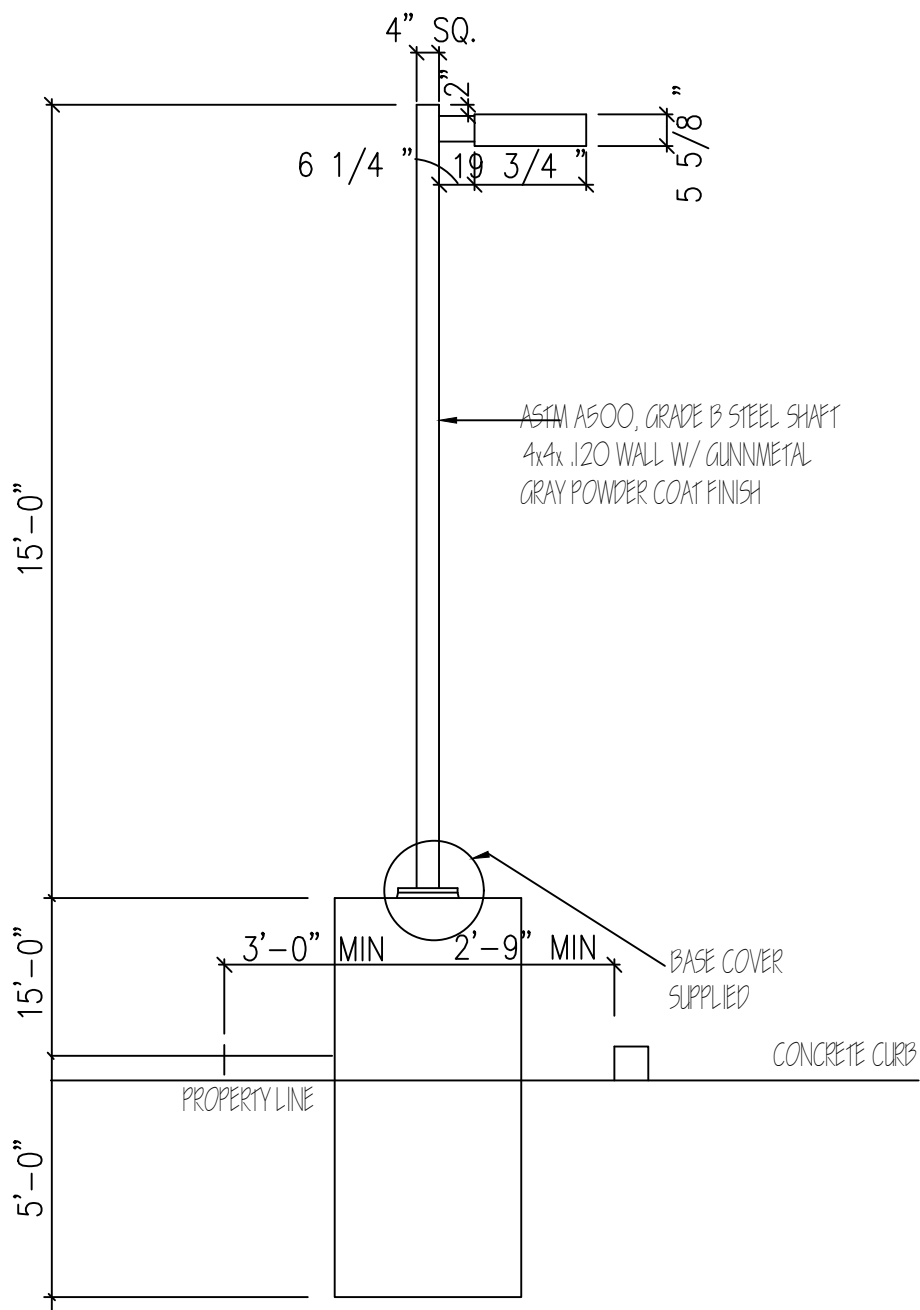

A & M
CONSULTANTS

835 MASON ST.
STE. B 290
DEARBORN,
MI.48124
PH: (313) 790-0129
FAX:(313) 582-0028

PROJECT:
CONSTRUCTION
3037 E GRAND BLVD.
Detroit, MI.48202

CLIENT:
MCORP 3037 E
GRAND BLVD
LLC.
12958 Michigan Ave,
Dearborn, MI. 48126
Issued:

05 / 28 /2026
08 /26 /2026

NOTE:
Do not scale drawings. Use
calculated dimensions only.
Verify existing conditions in
field.

SHEET# TITLE:
ELECTRICAL SITE
PLAN
SCALE:

1"=20'-0"
PROJECT NUMBER:
25-68
SHEET NUMBER:
ES100
SEAL:

